

DEVELOPMENT ORDER AMENDMENT #3

FOR

WILDBLUE SOUTHWEST

PART OF SECTION 17-20 TOWNSHIP 46 SOUTH, RANGE 26 EAST
FORT MYERS, LEE COUNTY, FLORIDA

PROJECT DATA

SITE ADDRESS	PROJECT DATUM	
13500 ALICO ROAD FORT MYERS, FLORIDA 33913	STATE PLANE FLORIDA WEST ZONE NAD 1983 (NSRS2007) NORTH AMERICAN VERTICAL DATUM (NAVD) 1988	
ZONING	RECORD PLAT	
MPD (RESOLUTION Z-15-021)	PENDING	
FLOOD ZONE	STRAP NUMBERS	
ACCORDING TO THE FLOOD INSURANCE RATE MAP NO. 12071C0625F, EFFECTIVE DATE: AUGUST 28, 2008, THE SUBJECT PARCEL IS LOCATED IN FLOOD ZONE "X" (NO SPECIAL FLOOD HAZARD AREA)	19-46-26-L2-070F2.0000 19-46-26-L2-070F2.0010 19-46-26-L2-070F2.0020 19-46-26-L2-070F2.0030	
PERMIT REQUIREMENTS		
AGENCY	STATUS	NOTES
S. FLORIDA WATER MANAGEMENT DISTRICT	APPROVED	36-05075-P
LEE COUNTY DEVELOPMENT ORDER	APPROVED	DOS2018-00007
FLORIDA DEPARTMENT OF HEALTH	APPROVED	0217283-220DSGP
FLORIDA DEPT. OF ENVIRONMENTAL PROTECTION	APPROVED	38436-418-DWC/CM
F.D.O.T. CONNECTION PERMIT	N/A	-
F.D.O.T. DRAINAGE CONNECTION PERMIT	N/A	-
F.D.O.T. UTILITY PERMIT	N/A	-
ARMY CORPS OF ENGINEERS	APPROVED	SAJ-2003-10995
F.D.E.P. NOTICE OF INTENT	APPROVED	-

NOTE: CONTRACTOR MUST OBTAIN AND KEEP ON FILE A COPY OF ALL PERMITS
REQUIRED PRIOR TO COMMENCEMENT OF ANY CONSTRUCTION ACTIVITY

DESIGN TEAM


PROJECT ENGINEER	PROJECT MANAGEMENT
CARL A. BARRACO, P.E.	CHRIS VAN BUSKIRK
DESIGN ENGINEER	PROJECT SURVEYOR
TIMOTHY B. GAVIN, P.E.	SCOTT A. WHEELER, PSM
LEAD DESIGN TECHNICIAN	SITE PLANNING
GUY SAPEN	JENNIFER SAPEN
DESIGN STAFF	LAND PLANNING
SCOTT A. WHEELER, JR.	-
QUALITY CONTROL	RECORD DRAWINGS
CHRIS VAN BUSKIRK	-

THESE PLANS MAY HAVE BEEN MODIFIED IN SIZE BY REPRODUCTION.
THIS MUST BE CONSIDERED WHEN OBTAINING SCALED DATA.


ALL DIMENSIONS ARE IN FEET.



PROJECT
LOCATION

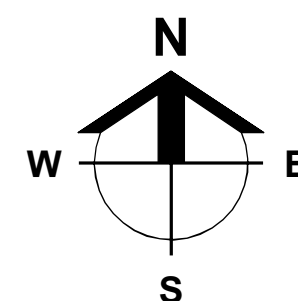

LOCATION MAP

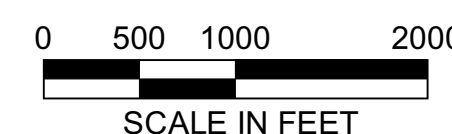

SCALE IN FEET



INDEX OF DRAWINGS

SHEET	DESCRIPTION	XREF	DRAWING NAME
C1.0	COVER SHEET AND LOCATION MAP	A	23526A01.DWG
C2.0	STANDARD NOTES, LEGEND AND ABBREVIATIONS	-	23526A02.DWG
C3.0	AERIAL PHOTOGRAPH AND EXISTING CONDITIONS PLAN	A	23526A06.DWG
C4.0	MASTER SITE AND PHASING PLAN	A	23526A10.DWG
C4.1	MODEL HOME PARKING PLAN	A	23526A10B.DWG
C5.0	MASTER DRAINAGE PLAN	A	23526A11.DWG
C6.0	MASTER UTILITY PLAN	A	23526A12.DWG
C7.11-C7.12, C7.14-C7.16, C7.19-C7.20	DETAILED PAVING, GRADING, AND DRAINAGE PLANS	A	23526A15.DWG
C8.0-C8.5	TYPICAL SECTIONS	-	23526A18.DWG
C9.0	PLAN AND PROFILE KEY SHEET	A	23526A29.DWG
C10.0-C10.8	PLAN AND PROFILES - WILDBLUE BLVD. (STA: 400 & 500)	A,B	23526A30A.DWG
C11.0	PLAN AND PROFILES - AQUA RESERVE CT. (STA: 600)	A,B	23526A30B.DWG
C12.0-C12.1	PLAN AND PROFILES - WATERMAN CT. (STA: 700)	A,B	23526A30C.DWG
C13.0-C13.2	PLAN AND PROFILES - AQUA VIEW LN. (STA: 800)	A,B	23526A30D.DWG
C14.0-C14.2	PLAN AND PROFILES - MARQUESA DR. (STA: 900)	A,B	23526A30E.DWG
C15.0-C15.8 - C16.0-C16.8	PLAN AND PROFILES - AQUA SHORE DR. (STA: 1000)	A,B	23526A30F.DWG
C16.0	PLAN AND PROFILES - WATER FERN WAY (STA: 1100)	A,B	23526A30G.DWG
C17.0	PLAN AND PROFILES - LIFT STATIONS 7883 & 7884	A,B	23526A30H.DWG
C18.0	CONTROL STRUCTURE DETAILS	-	23526A42.DWG
C19.0	C19.0-C19.2 TYPICAL CONSTRUCTION DETAILS	-	23526A44.DWG
C20.0	EROSION CONTROL DETAILS	-	23526A50.DWG
C21.0	STORMWATER POLLUTION PREVENTION PLAN	A	23526A52.DWG
C22.0-C22.3	UTILITY DETAILS	-	23526A70.DWG
C23.0-C23.2	LIFT STATION 7883 & 7884 DETAILS	-	23526A71.DWG
C24.0, C24.8-C24.9	STREET LIGHTING PLANS	A	23526A86.DWG
C25.0-C25.1	OFFSITE TURN LANES CORKSCREW ROAD	A	23526A90.DWG
C26.0	DEWATERING PLAN	-	23526A93.DWG
C27.0	DEEP LAKE MANAGEMENT PLAN	-	23526A94.DWG
C28.0-C28.1	CLEARING & EARTHWORK PLAN	-	23526A99A.DWG
C29.0-C29.1	CLEARING & EARTHWORK PLAN SECTIONS	-	23526A99B.DWG

CROSS-REFERENCED DRAWINGS:

XREF	DESCRIPTION	DRAWING NAME
A	BASE LINWORK PLAN	23526A00.DWG
B	PROFILE BASE PLAN	23526A00P.DWG
C	SURVEY BASE PLAN	23372S00.DWG

PLAN STATUS

D.O. AMENDMENT #3
06-05-2019

Barraco
and Associates, Inc.
CIVIL ENGINEERING - LAND SURVEYING
LAND PLANNING

www.barraco.net

2271 MCGREGOR BLVD., SUITE 100
POST OFFICE DRAWER 2800
FORT MYERS, FLORIDA 33902-2800
PHONE (239) 461-3170
FAX (239) 461-3169

FLORIDA CERTIFICATES OF AUTHORIZATION
ENGINEERING 7995 - SURVEYING LB-6940

PREPARED FOR



PULTE HOME CORPORATION
24311 WALDEN CENTER DRIVE
SUITE 300
BONITA SPRINGS, FLORIDA 34134

PHONE (239) 498-7711
FAX (239) 498-7707

WWW.PULTEHOMES.COM

PROJECT DESCRIPTION

WILDBLUE
SOUTHWEST

LEE COUNTY, FLORIDA

ENGINEER OF RECORD

CARL A. BARRACO, P.E., FOR THE FIRM
FLORIDA P.E. NO. 38536 - CARLB@BARRACO.NET

Digitally signed
by Carl A.
Barraco, P.E.
Date: 2019.06.12
13:37:26 -04'00'

This item has been electronically signed and sealed using a
SHA-1 authentication code.

Printed copies of this document are not considered signed and
sealed and the SHA-1 authentication code must be verified on
any electronic copies.

DRAWING NOT VALID WITHOUT SEAL, SIGNATURE AND DATE.
© COPYRIGHT 2019, BARRACO AND ASSOCIATES, INC.
REPRODUCTION, CHANGES OR ASSIGNMENTS ARE PROHIBITED.

FILE NAME J:\23526\DWG\DO SPINE ROAD\

LOCATION J:\23526\DWG\DO SPINE ROAD\

PLOT DATE WED, 6-5-2019 - 2:28 PM

PLOT BY SCOTT WHEELER JR

CROSS REFERENCED DRAWINGS

MASTER = BA1-COVER-1.DWG

PLAN REVISIONS


DATE	DESCRIPTION	BY
06-03-19	D.O. AMENDMENT #3 CHANGES	


PLAN STATUS

D.O. AMENDMENT #3
06-05-2019

COVER SHEET
AND
LOCATION MAP

PROJECT / FILE NO.	SHEET NUMBER
23526	C1.0

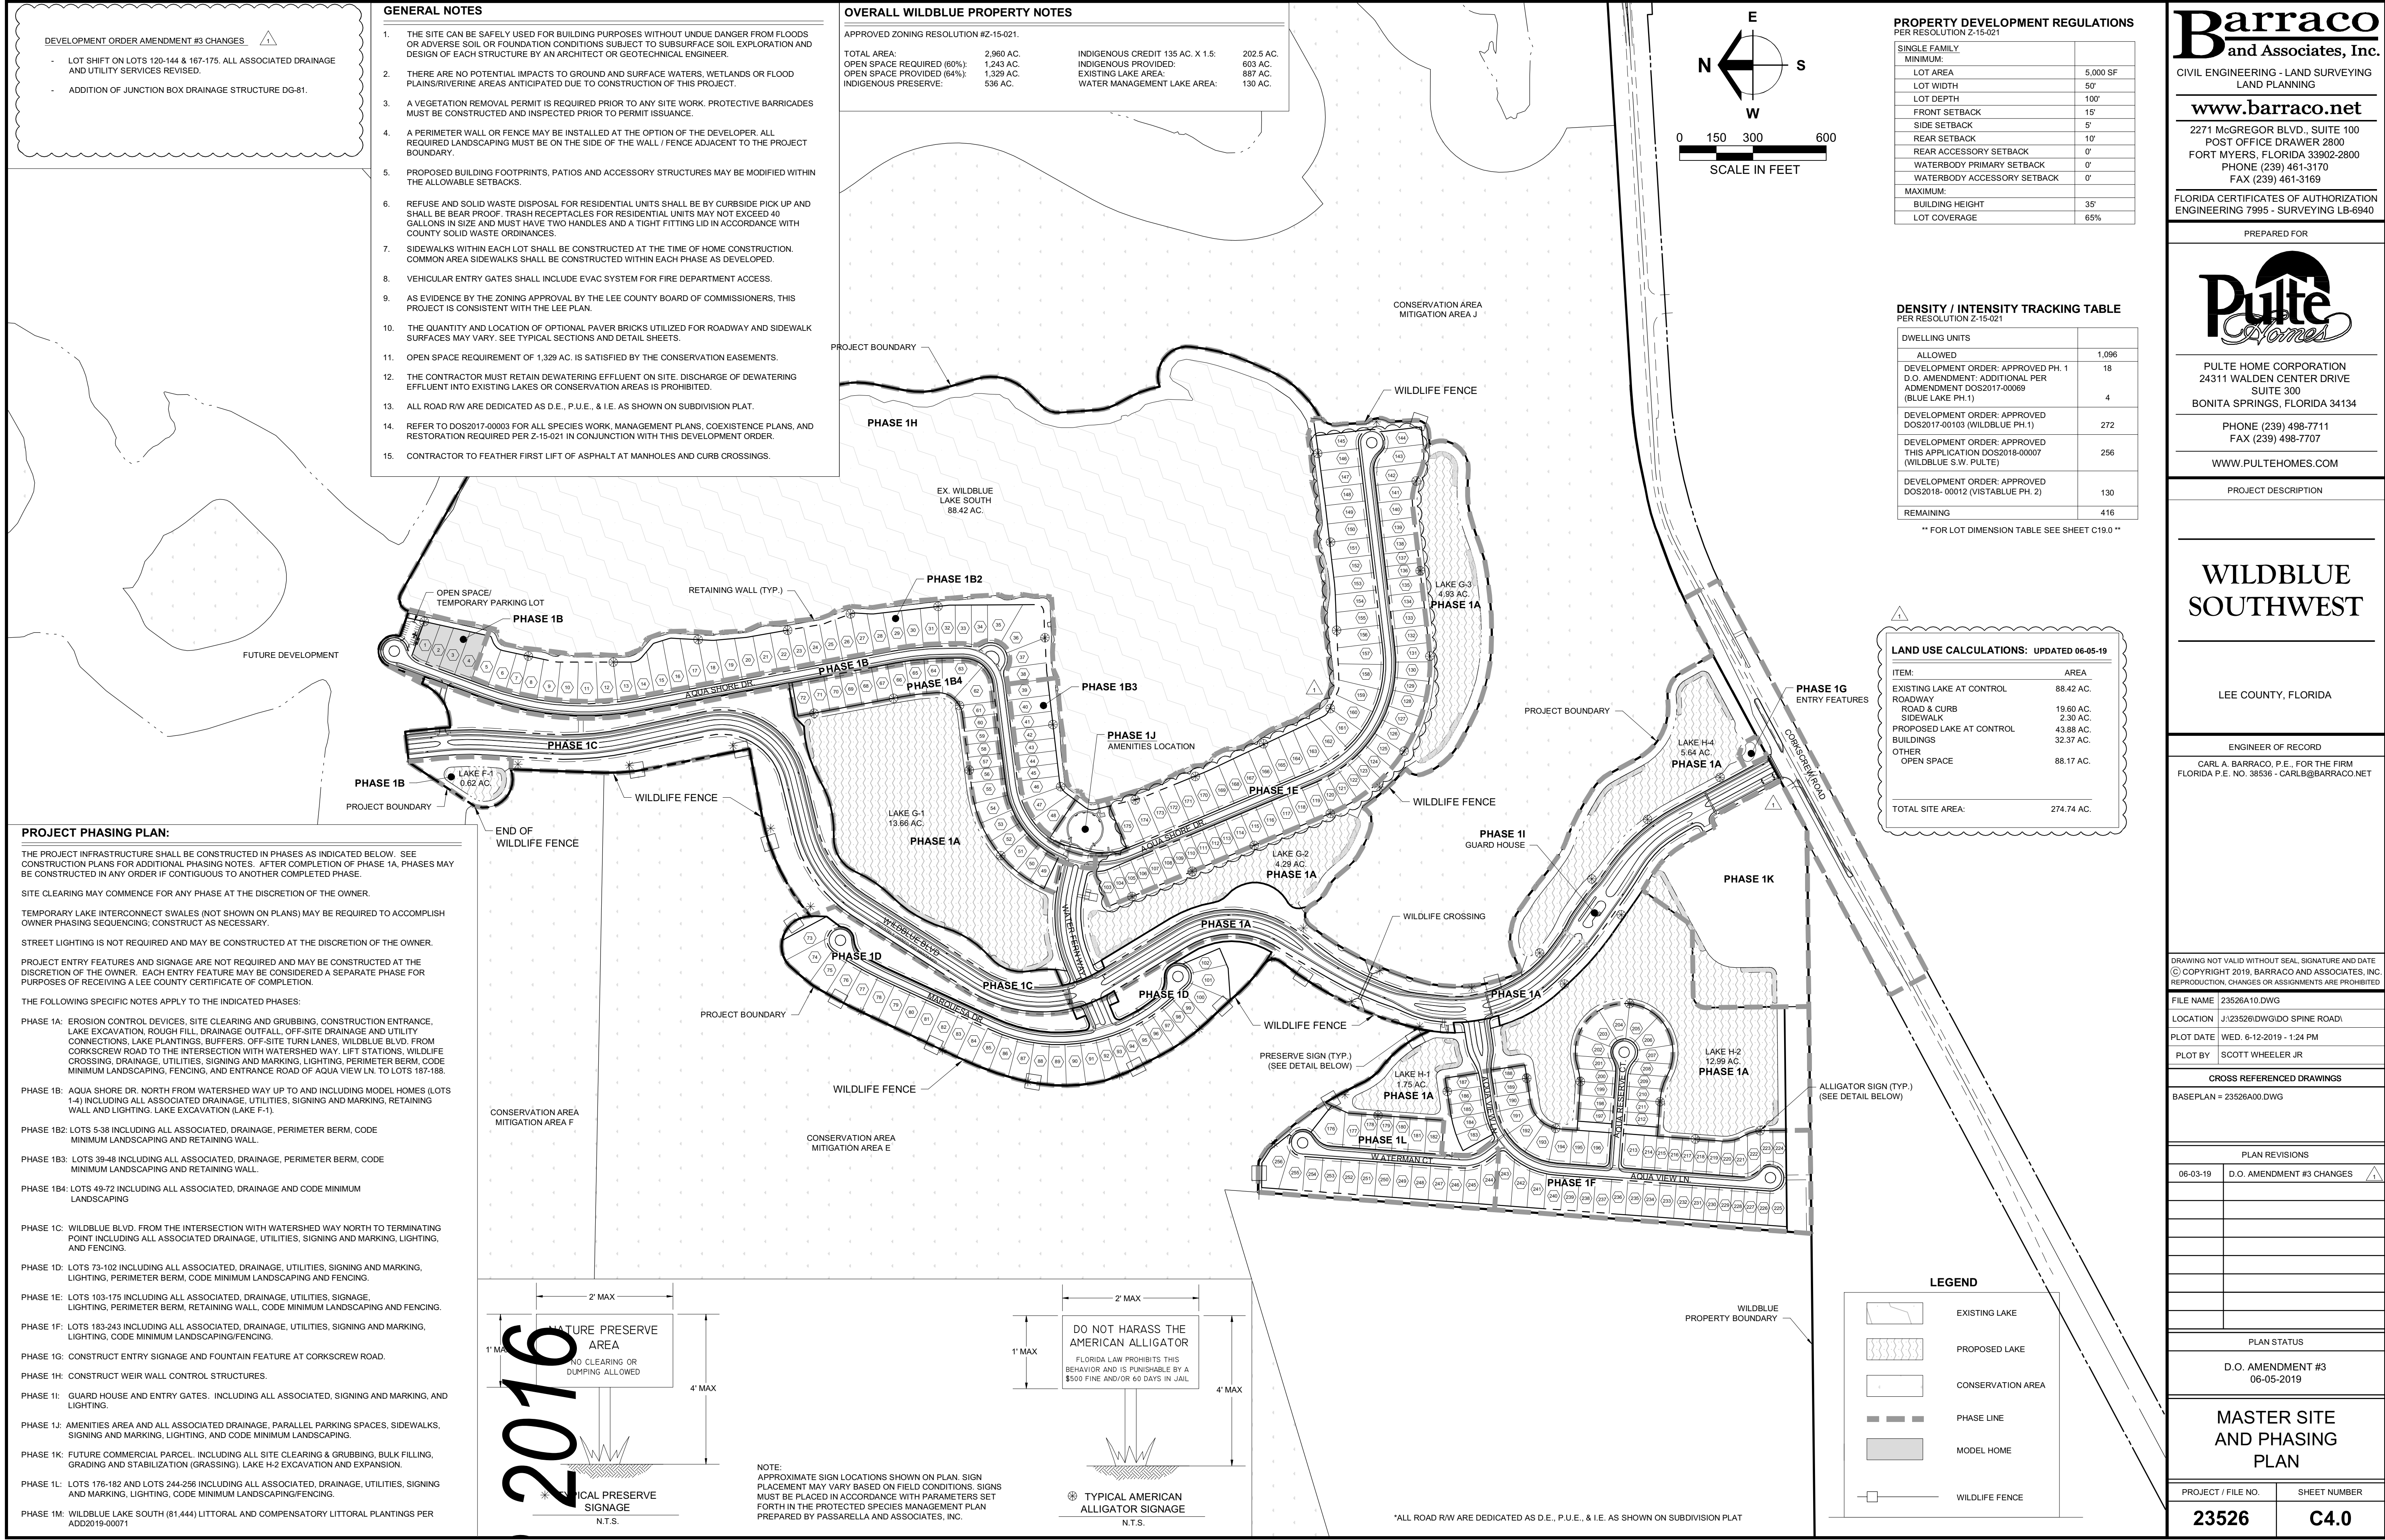

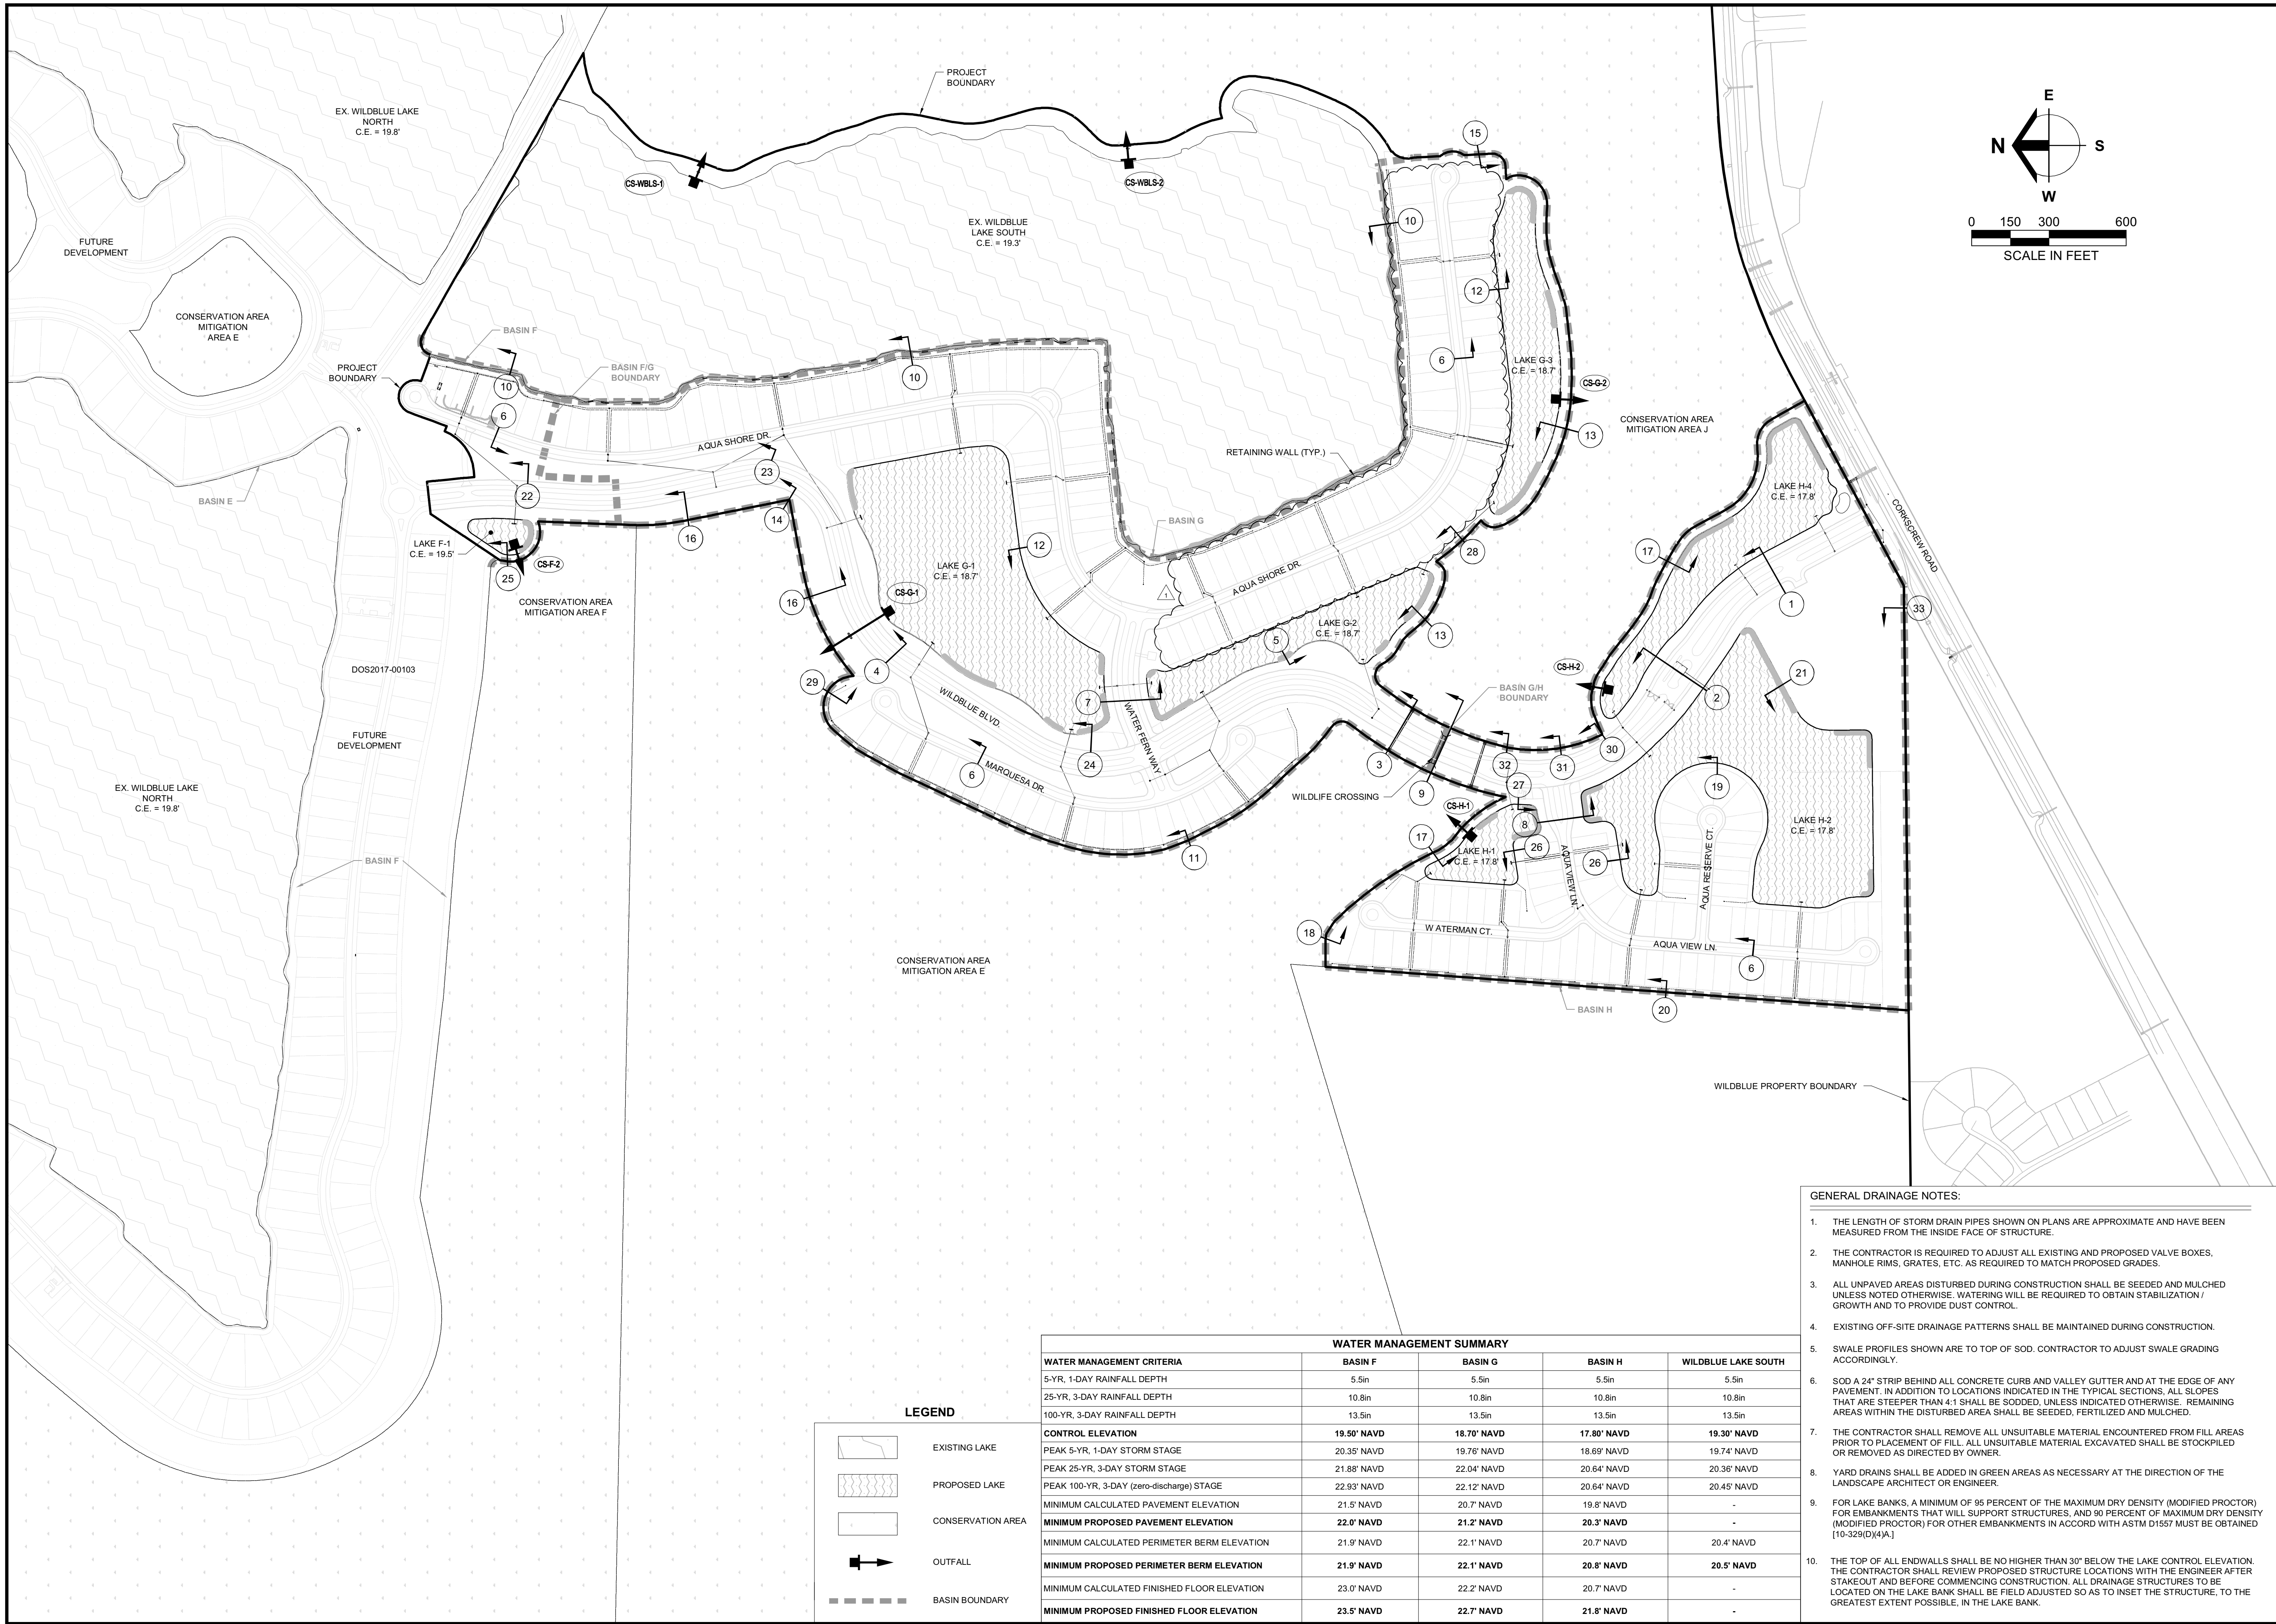

WATER MANAGEMENT SUMMARY				
WATER MANAGEMENT CRITERIA	BASIN F	BASIN G	BASIN H	WILDBLUE LAKE SOUTH
5-YR, 1-DAY RAINFALL DEPTH	5.5in	5.5in	5.5in	5.5in
25-YR, 3-DAY RAINFALL DEPTH	10.8in	10.8in	10.8in	10.8in
100-YR, 3-DAY RAINFALL DEPTH	13.5in	13.5in	13.5in	13.5in
CONTROL ELEVATION	19.50' NAVD	18.70' NAVD	17.80' NAVD	19.30' NAVD
PEAK 5-YR, 1-DAY STORM STAGE	20.35' NAVD	19.76' NAVD	18.69' NAVD	19.74' NAVD
PEAK 25-YR, 3-DAY STORM STAGE	21.88' NAVD	22.04' NAVD	20.64' NAVD	20.38' NAVD
PEAK 100-YR, 3-DAY (zero-discharge) STAGE	22.93' NAVD	22.12' NAVD	20.64' NAVD	20.45' NAVD
MINIMUM CALCULATED PAVEMENT ELEVATION	21.5' NAVD	20.7' NAVD	19.8' NAVD	-
MINIMUM PROPOSED PAVEMENT ELEVATION	22.0' NAVD	21.2' NAVD	20.3' NAVD	-
MINIMUM CALCULATED PERIMETER BERM ELEVATION	21.9' NAVD	22.1' NAVD	20.7' NAVD	20.4' NAVD
MINIMUM PROPOSED PERIMETER BERM ELEVATION	21.9' NAVD	22.1' NAVD	20.8' NAVD	20.5' NAVD
MINIMUM CALCULATED FINISHED FLOOR ELEVATION	23.0' NAVD	22.2' NAVD	20.7' NAVD	-
MINIMUM PROPOSED FINISHED FLOOR ELEVATION	23.5' NAVD	22.7' NAVD	21.8' NAVD	-

- GENERAL DRAINAGE NOTES:
- THE LENGTH OF STORM DRAIN PIPES SHOWN ON PLANS ARE APPROXIMATE AND HAVE BEEN MEASURED FROM THE INSIDE FACE OF STRUCTURE.
 - THE CONTRACTOR IS REQUIRED TO ADJUST ALL EXISTING AND PROPOSED VALVE BOXES, MANHOLE RIMS, GRATES, ETC. AS REQUIRED TO MATCH PROPOSED GRADES.
 - ALL UNPAVED AREAS DISTURBED DURING CONSTRUCTION SHALL BE SEEDED AND MULCHED UNLESS NOTED OTHERWISE. WATERING WILL BE REQUIRED TO OBTAIN STABILIZATION / GROWTH AND TO PROVIDE DUST CONTROL.
 - EXISTING OFF-SITE DRAINAGE PATTERNS SHALL BE MAINTAINED DURING CONSTRUCTION.
 - SWALE PROFILES SHOWN ARE TO TOP OF SOD. CONTRACTOR TO ADJUST SWALE GRADING ACCORDINGLY.
 - SOD A 24" STRIP BEHIND ALL CONCRETE CURB AND VALLEY GUTTER AND AT THE EDGE OF ANY PAVEMENT. IN ADDITION TO LOCATIONS INDICATED IN THE TYPICAL SECTIONS, ALL SLOPES THAT ARE STEEPER THAN 4:1 SHALL BE SODDED, UNLESS INDICATED OTHERWISE. REMAINING AREAS WITHIN THE DISTURBED AREA SHALL BE SEEDED, FERTILIZED AND MULCHED.
 - THE CONTRACTOR SHALL REMOVE ALL UNSUITABLE MATERIAL ENCOUNTERED FROM FILL AREAS PRIOR TO PLACEMENT OF FILL. ALL UNSUITABLE MATERIAL EXCAVATED SHALL BE STOCKPILED OR REMOVED AS DIRECTED BY OWNER.
 - YARD DRAINS SHALL BE ADDED IN GREEN AREAS AS NECESSARY AT THE DIRECTION OF THE LANDSCAPE ARCHITECT OR ENGINEER.
 - FOR LAKE BANKS, A MINIMUM OF 95 PERCENT OF THE MAXIMUM DRY DENSITY (MODIFIED PROCTOR) FOR EMBANKMENTS THAT WILL SUPPORT STRUCTURES, AND 90 PERCENT OF MAXIMUM DRY DENSITY (MODIFIED PROCTOR) FOR OTHER EMBANKMENTS IN ACCORD WITH ASTM D1557 MUST BE OBTAINED [10-329(D)(4)A.]
 - THE TOP OF ALL ENDWALLS SHALL BE NO HIGHER THAN 30" BELOW THE LAKE CONTROL ELEVATION. THE CONTRACTOR SHALL REVIEW PROPOSED STRUCTURE LOCATIONS WITH THE ENGINEER AFTER STAKEOUT AND BEFORE COMMENCING CONSTRUCTION. ALL DRAINAGE STRUCTURES TO BE LOCATED ON THE LAKE BANK SHALL BE FIELD ADJUSTED SO AS TO INSET THE STRUCTURE, TO THE GREATEST EXTENT POSSIBLE, IN THE LAKE BANK.

Barraco

and Associates, Inc.

CIVIL ENGINEERING - LAND SURVEYING
LAND PLANNING

www.barraco.net

2271 MCGREGOR BLVD., SUITE 100
POST OFFICE DRAWER 2800
FORT MYERS, FLORIDA 33902-2800
PHONE (239) 461-3170
FAX (239) 461-3169

FLORIDA CERTIFICATES OF AUTHORIZATION
ENGINEERING 7995 - SURVEYING LB-6940

PREPARED FOR

Pulte

Homeworks

PULTE HOME CORPORATION
24311 WALDEN CENTER DRIVE
SUITE 300
BONITA SPRINGS, FLORIDA 34134

PHONE (239) 498-7711
FAX (239) 498-7707

WWW.PULTEHOMES.COM

PROJECT DESCRIPTION

WILDBLUE
SOUTHWEST

LEE COUNTY, FLORIDA

ENGINEER OF RECORD

CARL A. BARRACO, P.E. FOR THE FIRM
FLORIDA P.E. NO. 38536 - CARLB@BARRACO.NET

DRAWING NOT VALID WITHOUT SEAL, SIGNATURE AND DATE.
© COPYRIGHT 2019, BARRACO AND ASSOCIATES, INC.
REPRODUCTION, CHANGES OR ASSIGNMENTS ARE PROHIBITED

FILE NAME J:\23526\A11.DWG

LOCATION J:\23526\DWG\DO SPINE ROAD\

PLOT DATE WED, 6-5-2019 - 2:29 PM

PLOT BY SCOTT WHEELER JR

CROSS REFERENCED DRAWINGS

PLAN REVISIONS


06-03-19	D.O. AMENDMENT #3 CHANGES	▲

PLAN STATUS

D.O. AMENDMENT #3
06-05-2019

MASTER
DRAINAGE
PLAN

PROJECT / FILE NO.	SHEET NUMBER
23526	C5.0

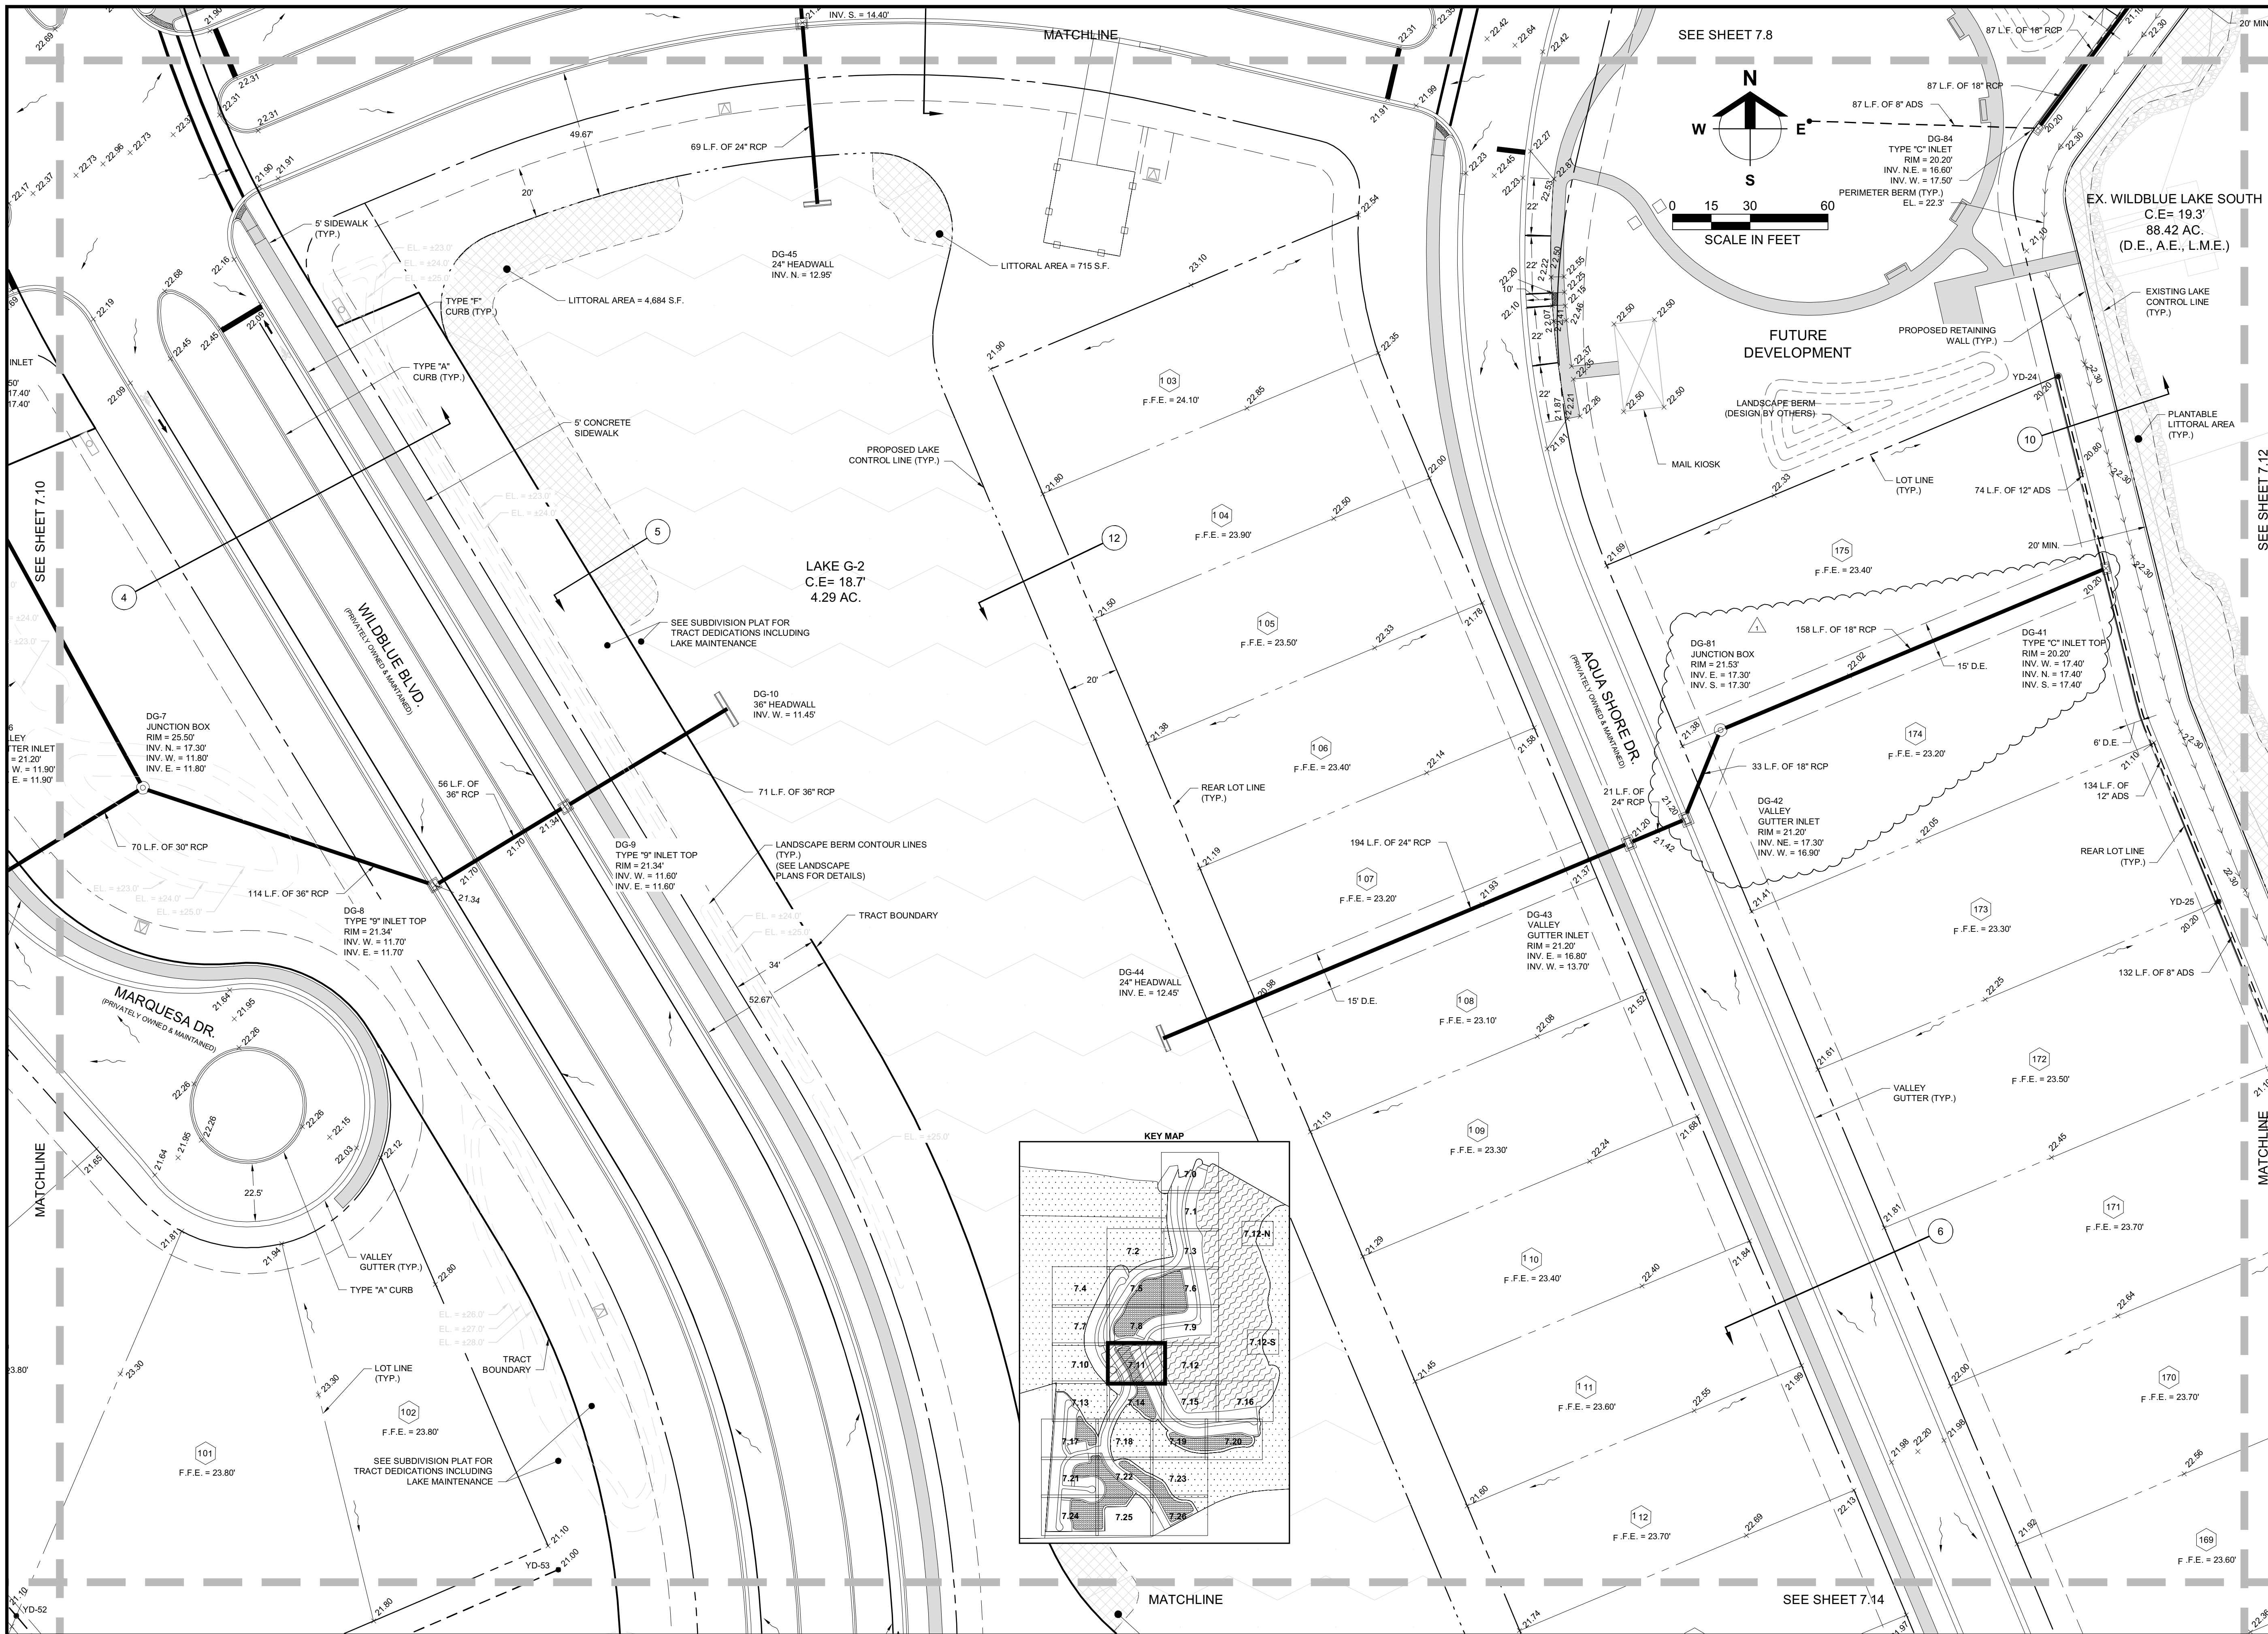

Barraco
and Associates, Inc.

CIVIL ENGINEERING - LAND SURVEYING
LAND PLANNING

www.barraco.net

2271 MCGREGOR BLVD., SUITE 100
POST OFFICE DRAWER 2800
FORT MYERS, FLORIDA 33902-2800
PHONE (239) 461-3170
FAX (239) 461-3169

FLORIDA CERTIFICATES OF AUTHORIZATION
ENGINEERING 7995 - SURVEYING LB-6940

PREPARED FOR


PULTE HOME CORPORATION
24311 WALDEN CENTER DRIVE
SUITE 300
BONITA SPRINGS, FLORIDA 34134
PHONE (239) 498-7711
FAX (239) 498-7707
WWW.PULTEHOMES.COM

PROJECT DESCRIPTION

**WILDBLUE
SOUTHWEST**

LEE COUNTY, FLORIDA

ENGINEER OF RECORD
CARL A. BARRACO, P.E. FOR THE FIRM
FLORIDA P.E. NO. 38536 - CARLB@BARRACO.NET

DRAWING NOT VALID WITHOUT SEAL, SIGNATURE AND DATE.
© COPYRIGHT 2019, BARRACO AND ASSOCIATES, INC.
REPRODUCTION, CHANGES OR ASSIGNMENTS ARE PROHIBITED

FILE NAME J:\23526\DWG\DO SPINE ROAD.DWG
LOCATION J:\23526\DWG\DO SPINE ROAD.DWG
PLOT DATE WED, 6-5-2019 - 2:29 PM
PLOT BY SCOTT WHEELER JR




CROSS REFERENCED DRAWINGS
BASEPLAN = 23526A00.DWG
SURVEY = 23372500.DWG

PLAN REVISIONS
06-03-19 D.O. AMENDMENT #3 CHANGES

PLAN STATUS
D.O. AMENDMENT #3
06-05-2019

DETAILED PAVING,
GRADING AND
DRAINAGE PLANS

PROJECT / FILE NO. 23526
SHEET NUMBER C7.11

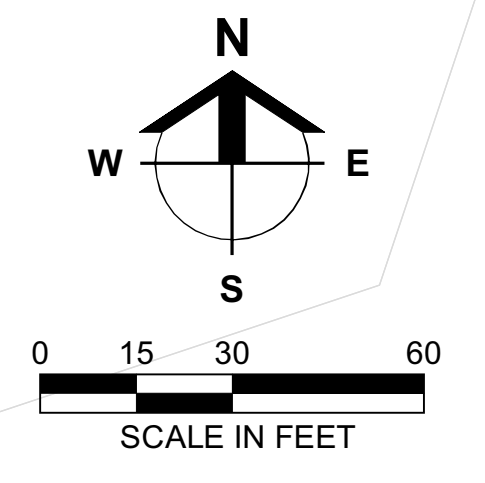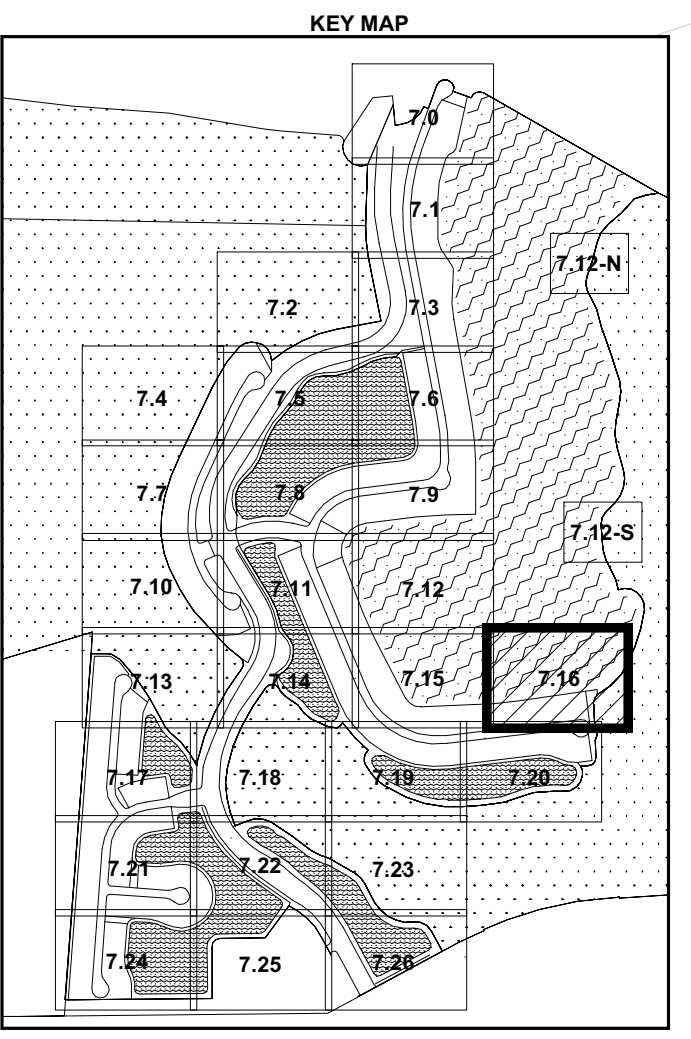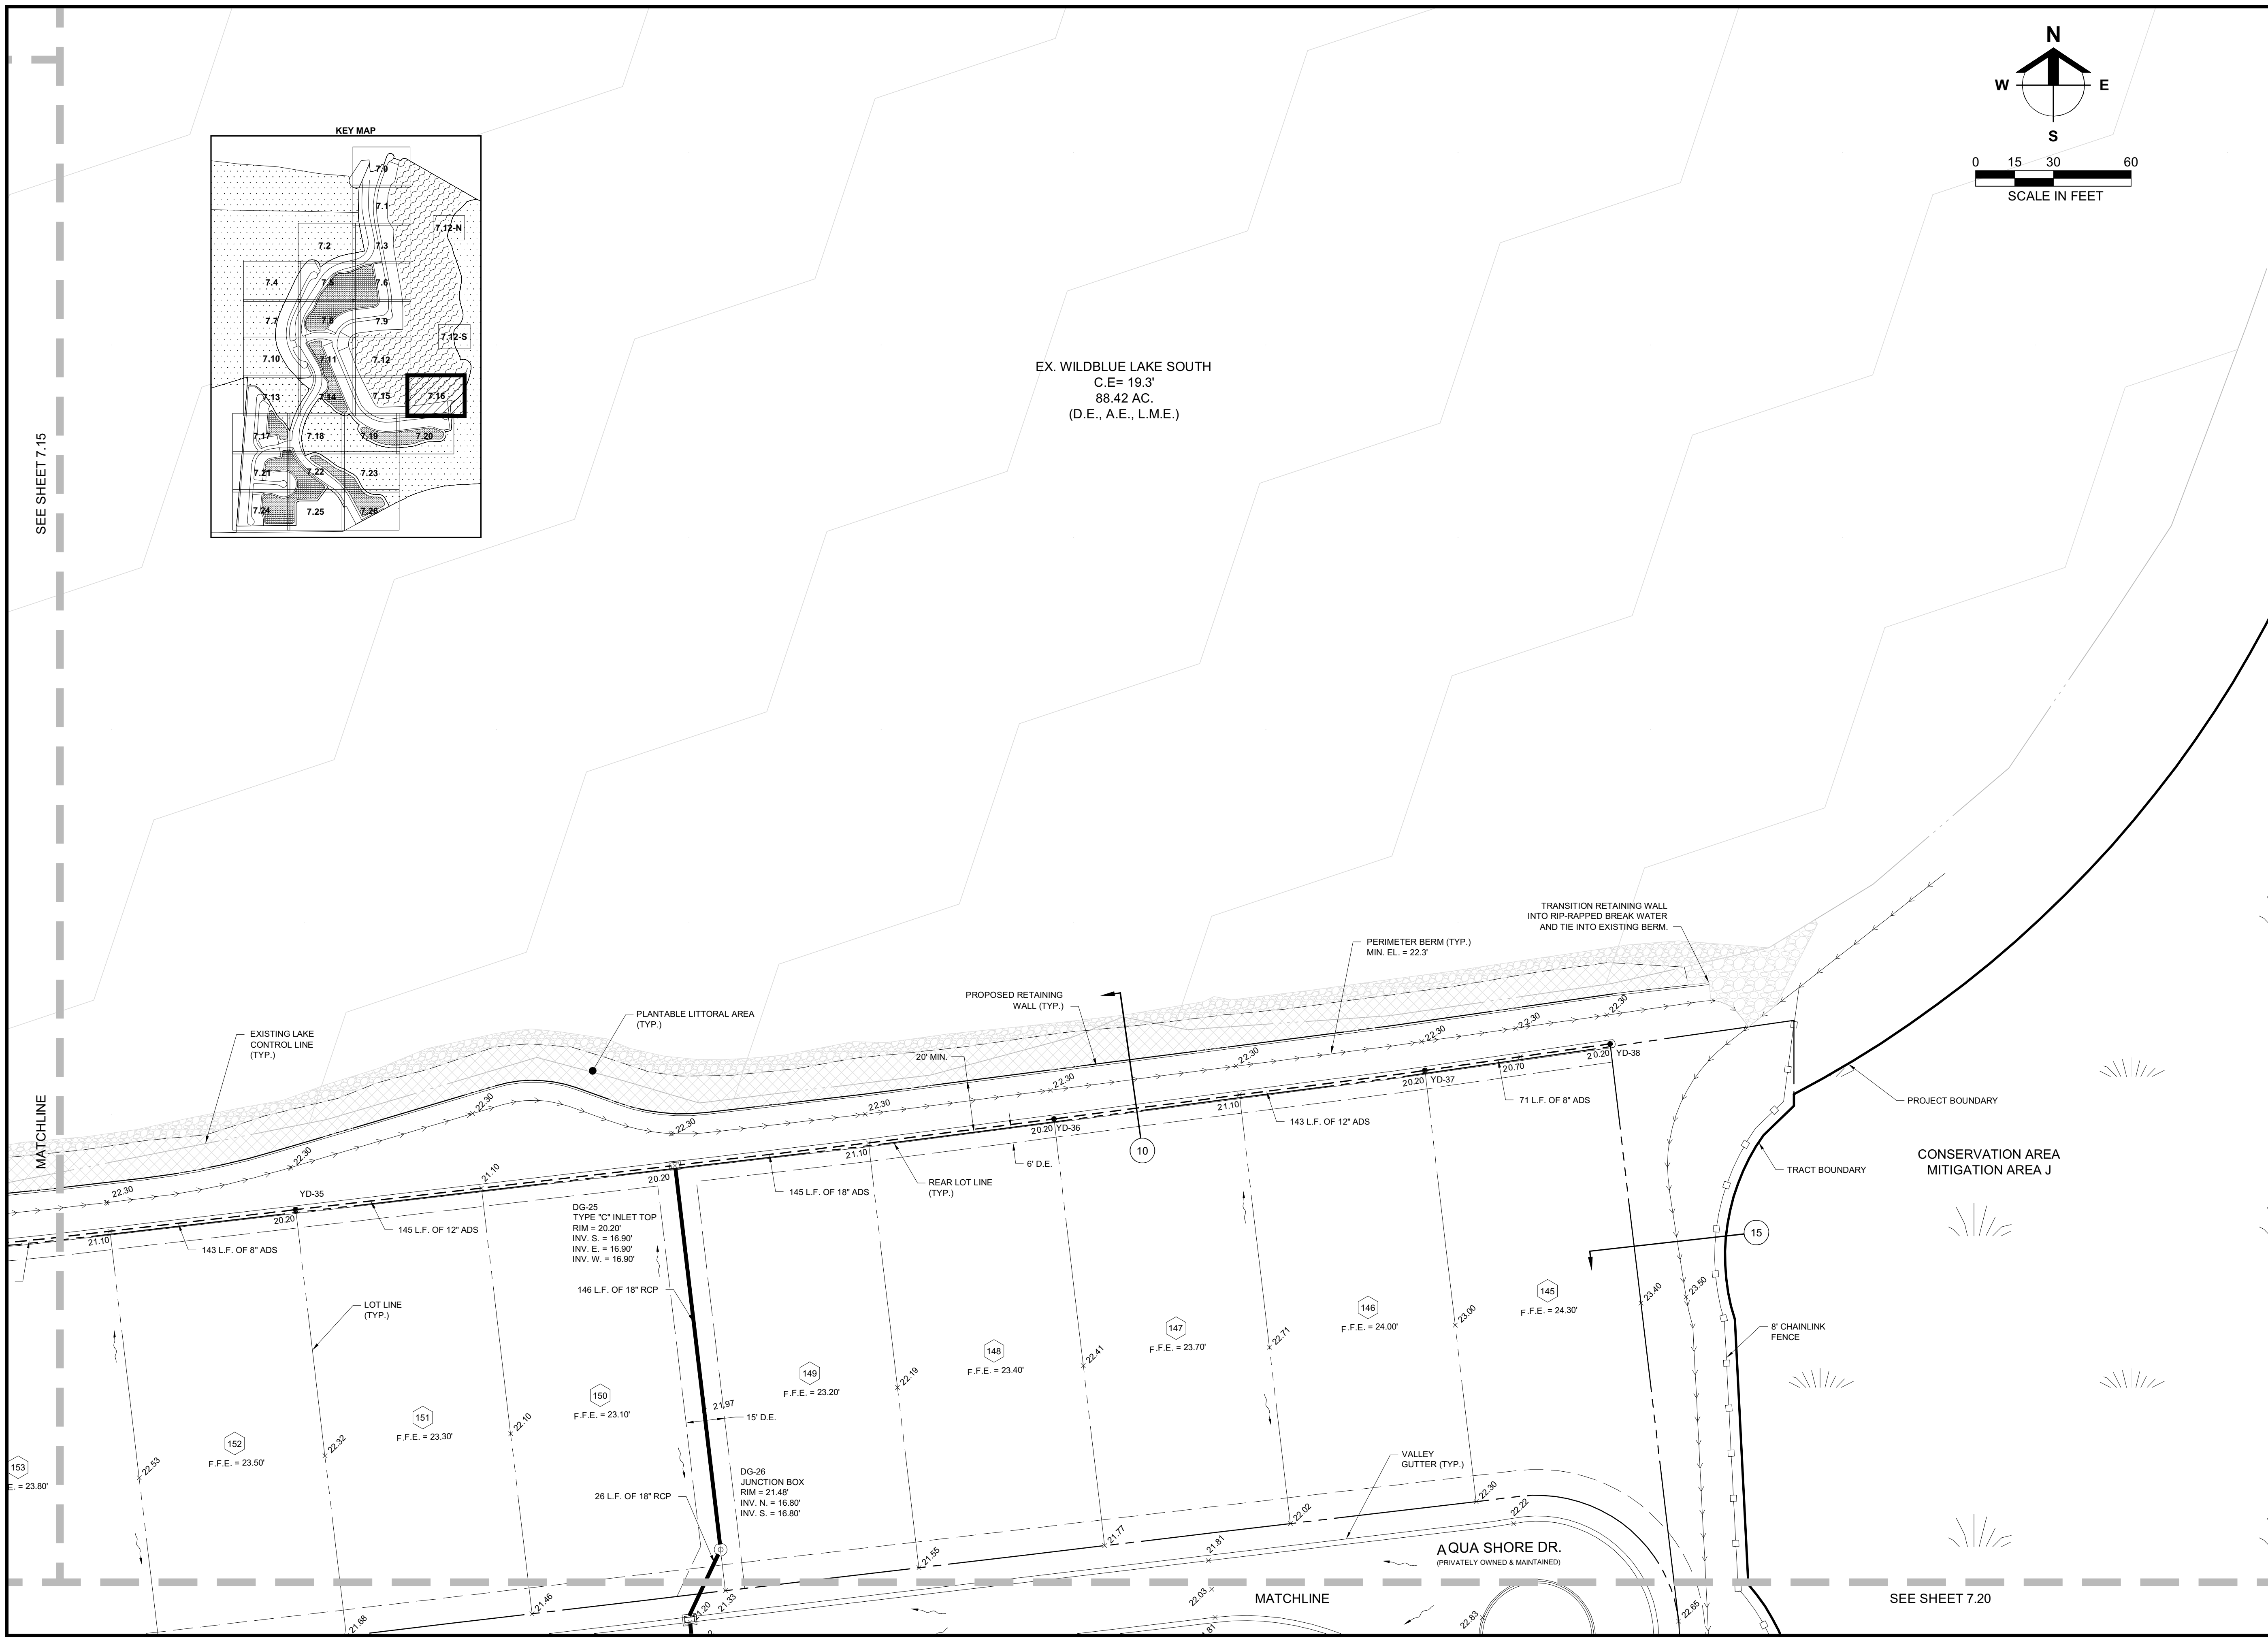

EX. WILDBLUE LAKE SOUTH
C.E= 19.3'
88.42 AC.
(D.E., A.E., L.M.E.)

Barraco
and Associates, Inc.
CIVIL ENGINEERING - LAND SURVEYING
LAND PLANNING
www.barraco.net
2271 MCGREGOR BLVD., SUITE 100
POST OFFICE DRAWER 2800
FORT MYERS, FLORIDA 33902-2800
PHONE (239) 461-3170
FAX (239) 461-3169
FLORIDA CERTIFICATES OF AUTHORIZATION
ENGINEERING 7995 - SURVEYING LB-6940

PREPARED FOR

PULTE HOME CORPORATION
24311 WALDEN CENTER DRIVE
SUITE 300
BONITA SPRINGS, FLORIDA 34134
PHONE (239) 498-7711
FAX (239) 498-7707
WWW.PULTEHOMES.COM



PROJECT DESCRIPTION

**WILDBLUE
SOUTHWEST**

LEE COUNTY, FLORIDA

ENGINEER OF RECORD
CARL A. BARRACO, P.E., FOR THE FIRM
FLORIDA P.E. NO. 38536 - CARLB@BARRACO.NET

DRAWING NOT VALID WITHOUT SEAL, SIGNATURE AND DATE.
© COPYRIGHT 2019, BARRACO AND ASSOCIATES, INC.
REPRODUCTION, CHANGES OR ASSIGNMENTS ARE PROHIBITED.
FILE NAME: 23526A15.DWG
LOCATION: J:\23526\DWG\DO SPINE ROAD\
PLOT DATE: WED. 6-5-2019 - 2:30 PM
PLOT BY: SCOTT WHEELER JR
CROSS REFERENCED DRAWINGS
BASEPLAN = 23526A00.DWG
SURVEY = 23372500.DWG
PLAN REVISIONS
06-03-19 D.O. AMENDMENT #3 CHANGES
PLAN STATUS
D.O. AMENDMENT #3
06-05-2019
**DETAILED PAVING,
GRADING AND
DRAINAGE PLANS**
PROJECT / FILE NO. **23526**
SHEET NUMBER **C7.16**

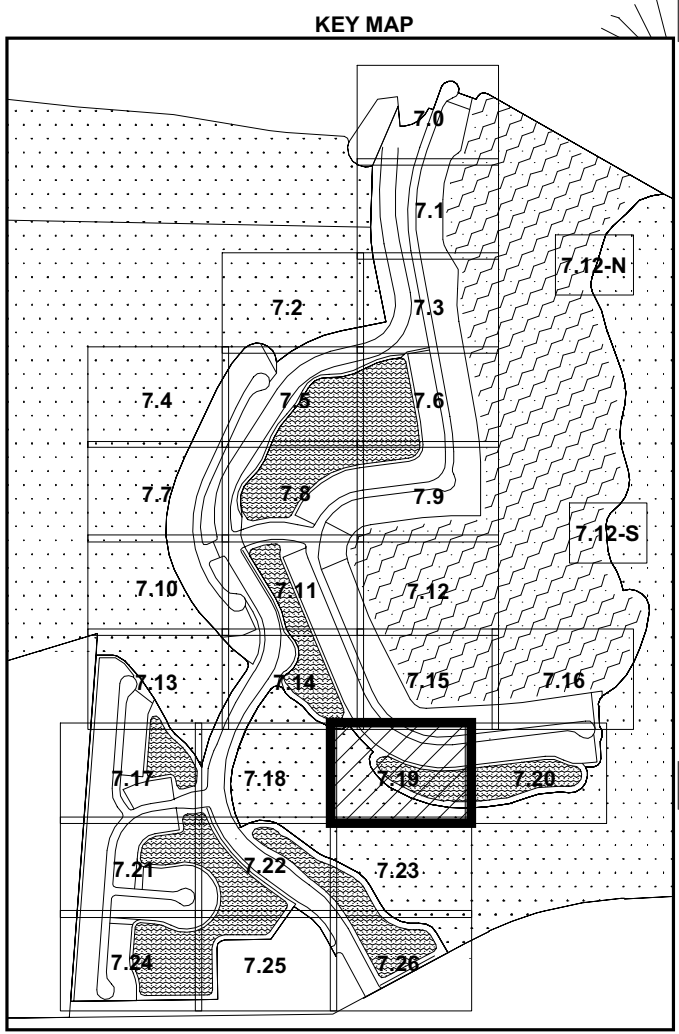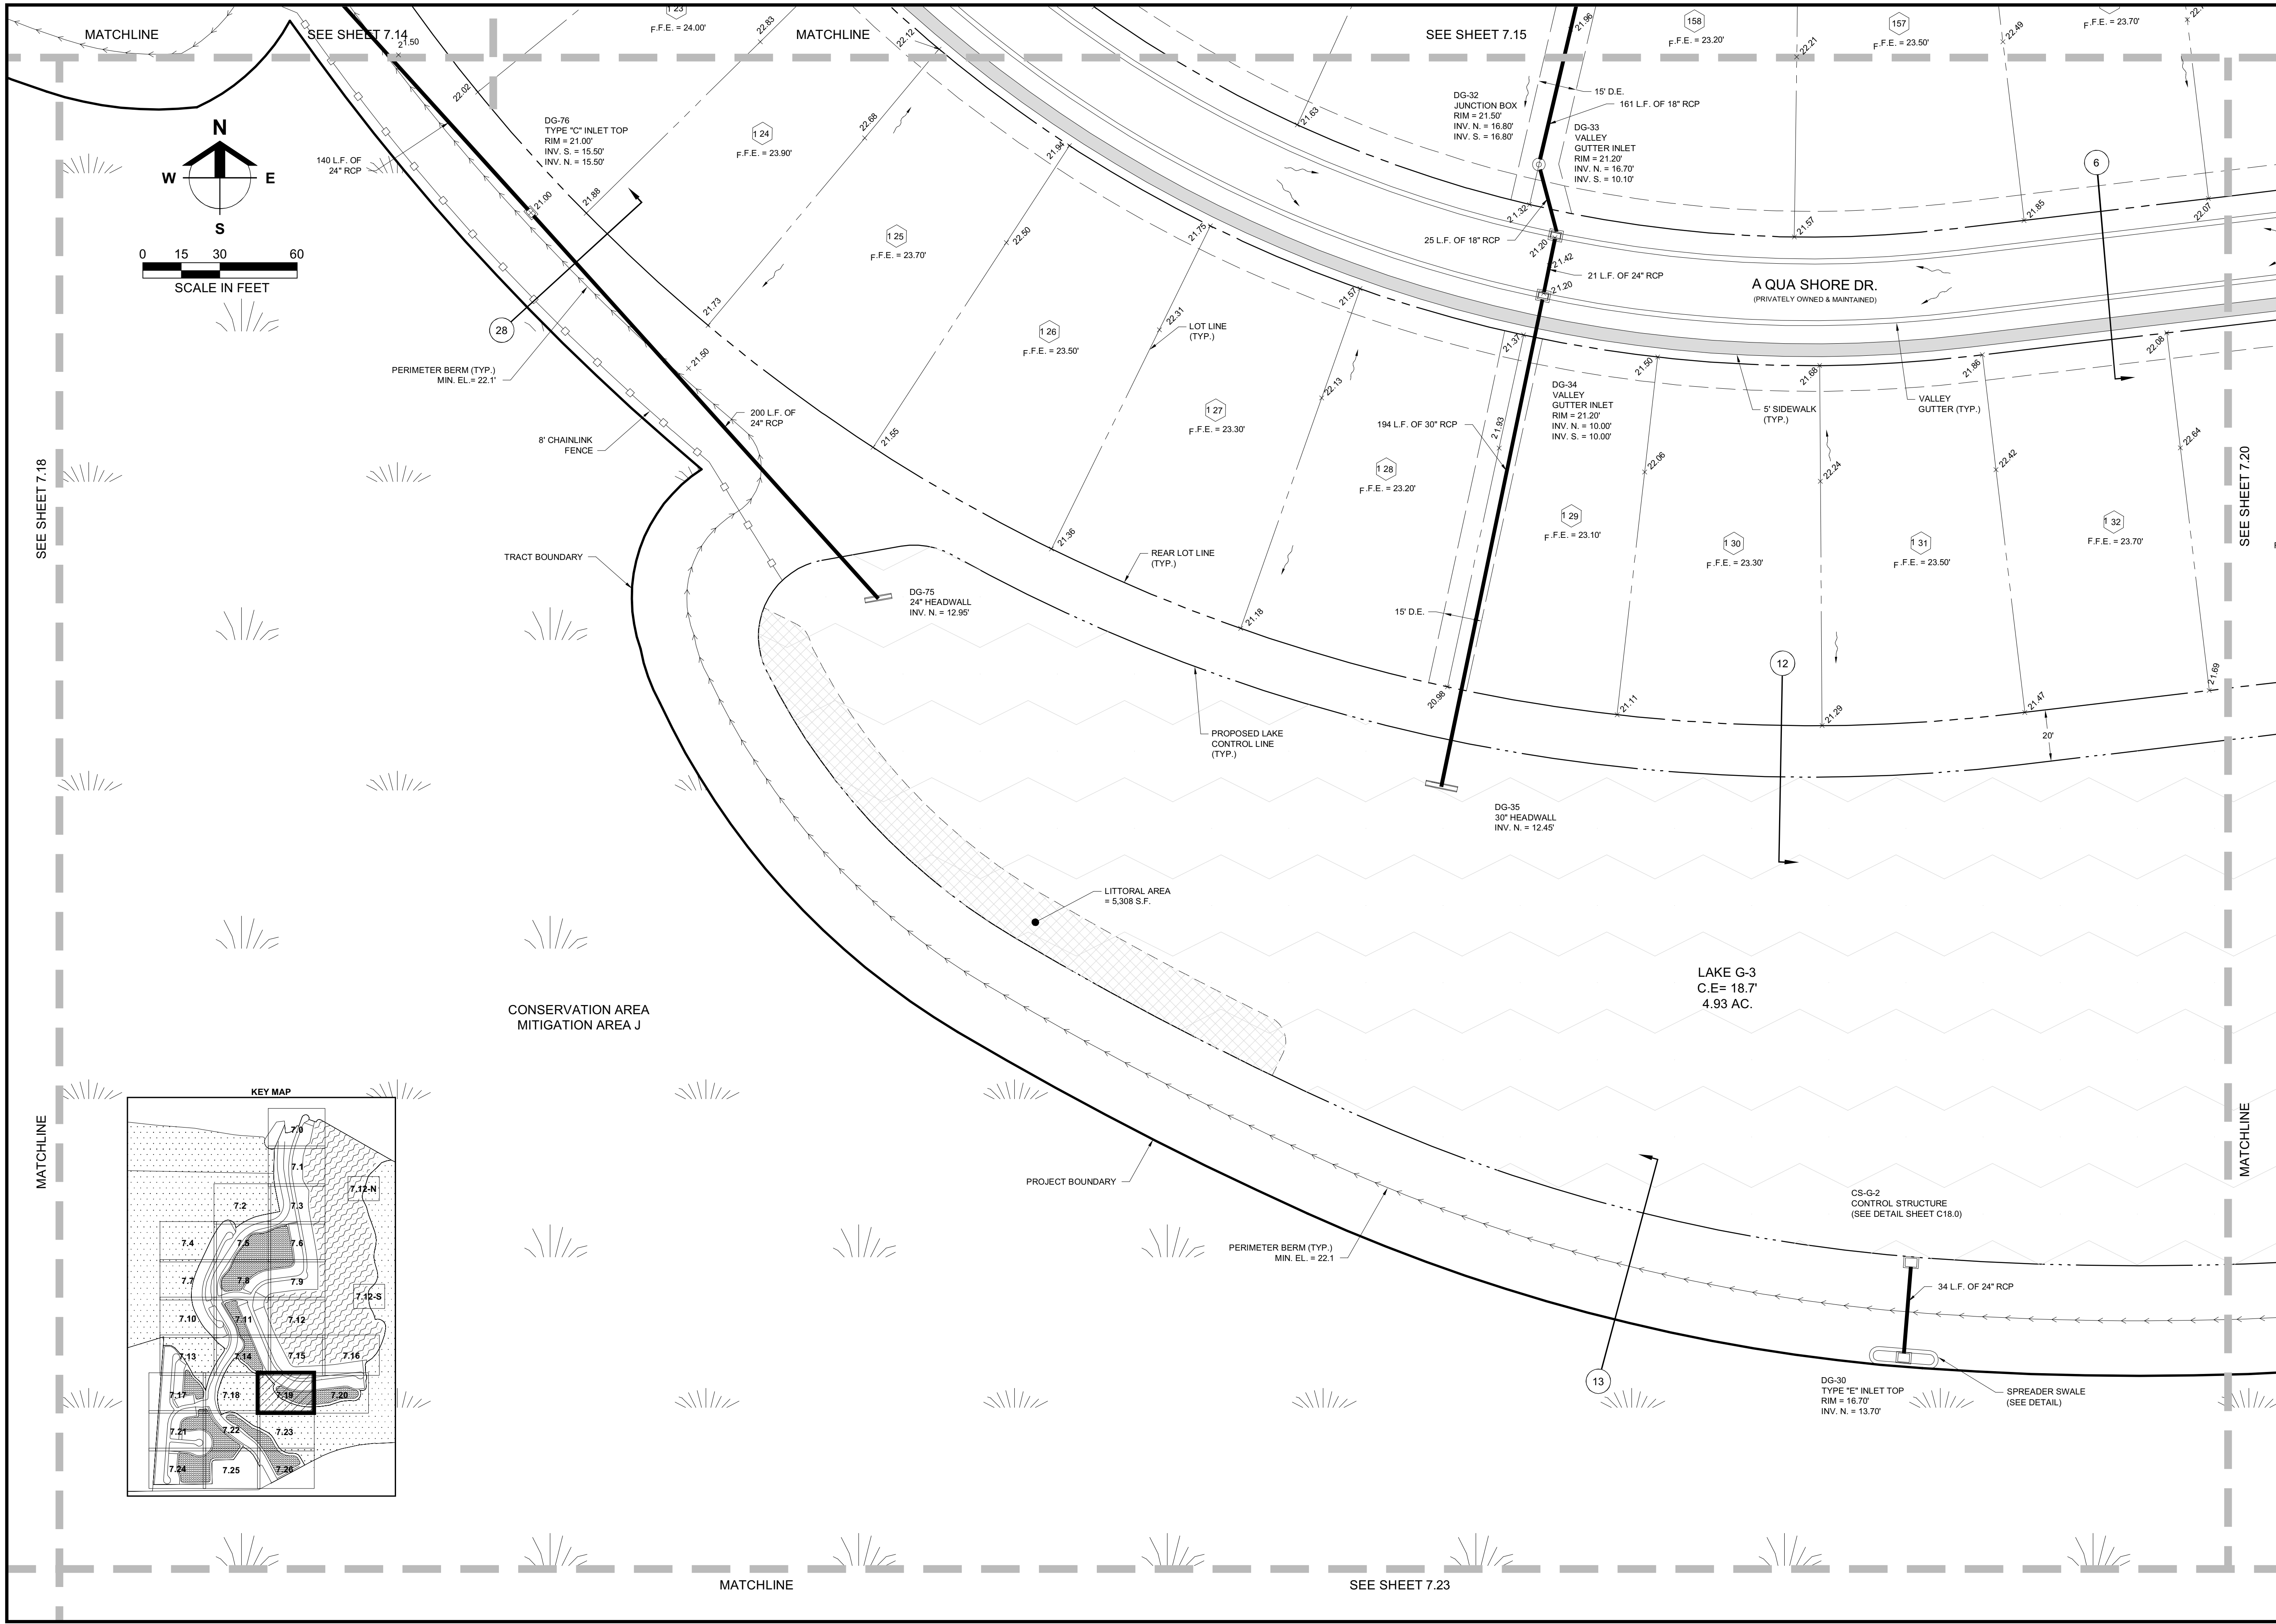

Barraco
and Associates, Inc.
CIVIL ENGINEERING - LAND SURVEYING
LAND PLANNING
www.barraco.net
2271 MCGREGOR BLVD., SUITE 100
POST OFFICE DRAWER 2800
FORT MYERS, FLORIDA 33902-2800
PHONE (239) 461-3170
FAX (239) 461-3169
FLORIDA CERTIFICATES OF AUTHORIZATION
ENGINEERING 7995 - SURVEYING LB-6940

PREPARED FOR

PULTE HOME CORPORATION
24311 WALDEN CENTER DRIVE
SUITE 300
BONITA SPRINGS, FLORIDA 34134
PHONE (239) 498-7711
FAX (239) 498-7707
WWW.PULTEHOMES.COM

PROJECT DESCRIPTION

**WILDBLUE
SOUTHWEST**

LEE COUNTY, FLORIDA

ENGINEER OF RECORD
CARL A. BARRACO, P.E. FOR THE FIRM
FLORIDA P.E. NO. 38536 - CARLB@BARRACO.NET

DRAWING NOT VALID WITHOUT SEAL, SIGNATURE AND DATE.
© COPYRIGHT 2019, BARRACO AND ASSOCIATES, INC.
REPRODUCTION, CHANGES OR ASSIGNMENTS ARE PROHIBITED

FILE NAME J:\23526\DWG\DO SPINE ROAD.DWG
LOCATION J:\23526\DWG\DO SPINE ROAD.DWG
PLOT DATE WED, 6-5-2019 - 2:31 PM
PLOT BY SCOTT WHEELER JR

CROSS REFERENCED DRAWINGS
BASEPLAN = 23526A00.DWG
SURVEY = 23372S00.DWG

PLAN REVISIONS
06-03-19 D.O. AMENDMENT #3 CHANGES

PLAN STATUS
D.O. AMENDMENT #3
06-05-2019

DETAILED PAVING,
GRADING AND
DRAINAGE PLANS

PROJECT / FILE NO. 23526
SHEET NUMBER C7.19



Barraco
and Associates, Inc.
CIVIL ENGINEERING - LAND SURVEYING
LAND PLANNING
www.barraco.net
2271 Mcgregor Blvd., Suite 100
Post Office Drawer 2800
Fort Myers, Florida 33902-2800
Phone (239) 461-3170
Fax (239) 461-3169
FLORIDA CERTIFICATES OF AUTHORIZATION
ENGINEERING 7995 - SURVEYING LB-6940

PREPARED FOR
Pulte
Homes
PULTE HOME CORPORATION
24311 WALDEN CENTER DRIVE
SUITE 300
BONITA SPRINGS, FLORIDA 34134
PHONE (239) 498-7711
FAX (239) 498-7707
WWW.PULTEHOMES.COM

PROJECT DESCRIPTION
**WILDBLUE
SOUTHWEST**

LEE COUNTY, FLORIDA

ENGINEER OF RECORD
CARL A. BARRACO, P.E. FOR THE FIRM
FLORIDA P.E. NO. 38536 - CARLB@BARRACO.NET

DRAWING NOT VALID WITHOUT SEAL, SIGNATURE AND DATE.
© COPYRIGHT 2019, BARRACO AND ASSOCIATES, INC.
REPRODUCTION, CHANGES OR ASSIGNMENTS ARE PROHIBITED.

FILE NAME J:\23526\15.DWG
LOCATION J:\23526\DWG\DO SPINE ROAD\
PLOT DATE WED, 6-5-2019 - 2:31 PM
PLOT BY SCOTT WHEELER JR


CROSS REFERENCED DRAWINGS
BASEPLAN = 23526A00.DWG
SURVEY = 23372500.DWG

PLAN REVISIONS
06-03-19 D.O. AMENDMENT #3 CHANGES

PLAN STATUS
D.O. AMENDMENT #3
06-05-2019

DETAILED PAVING,
GRADING AND
DRAINAGE PLANS

PROJECT / FILE NO. 23526
SHEET NUMBER C7.20

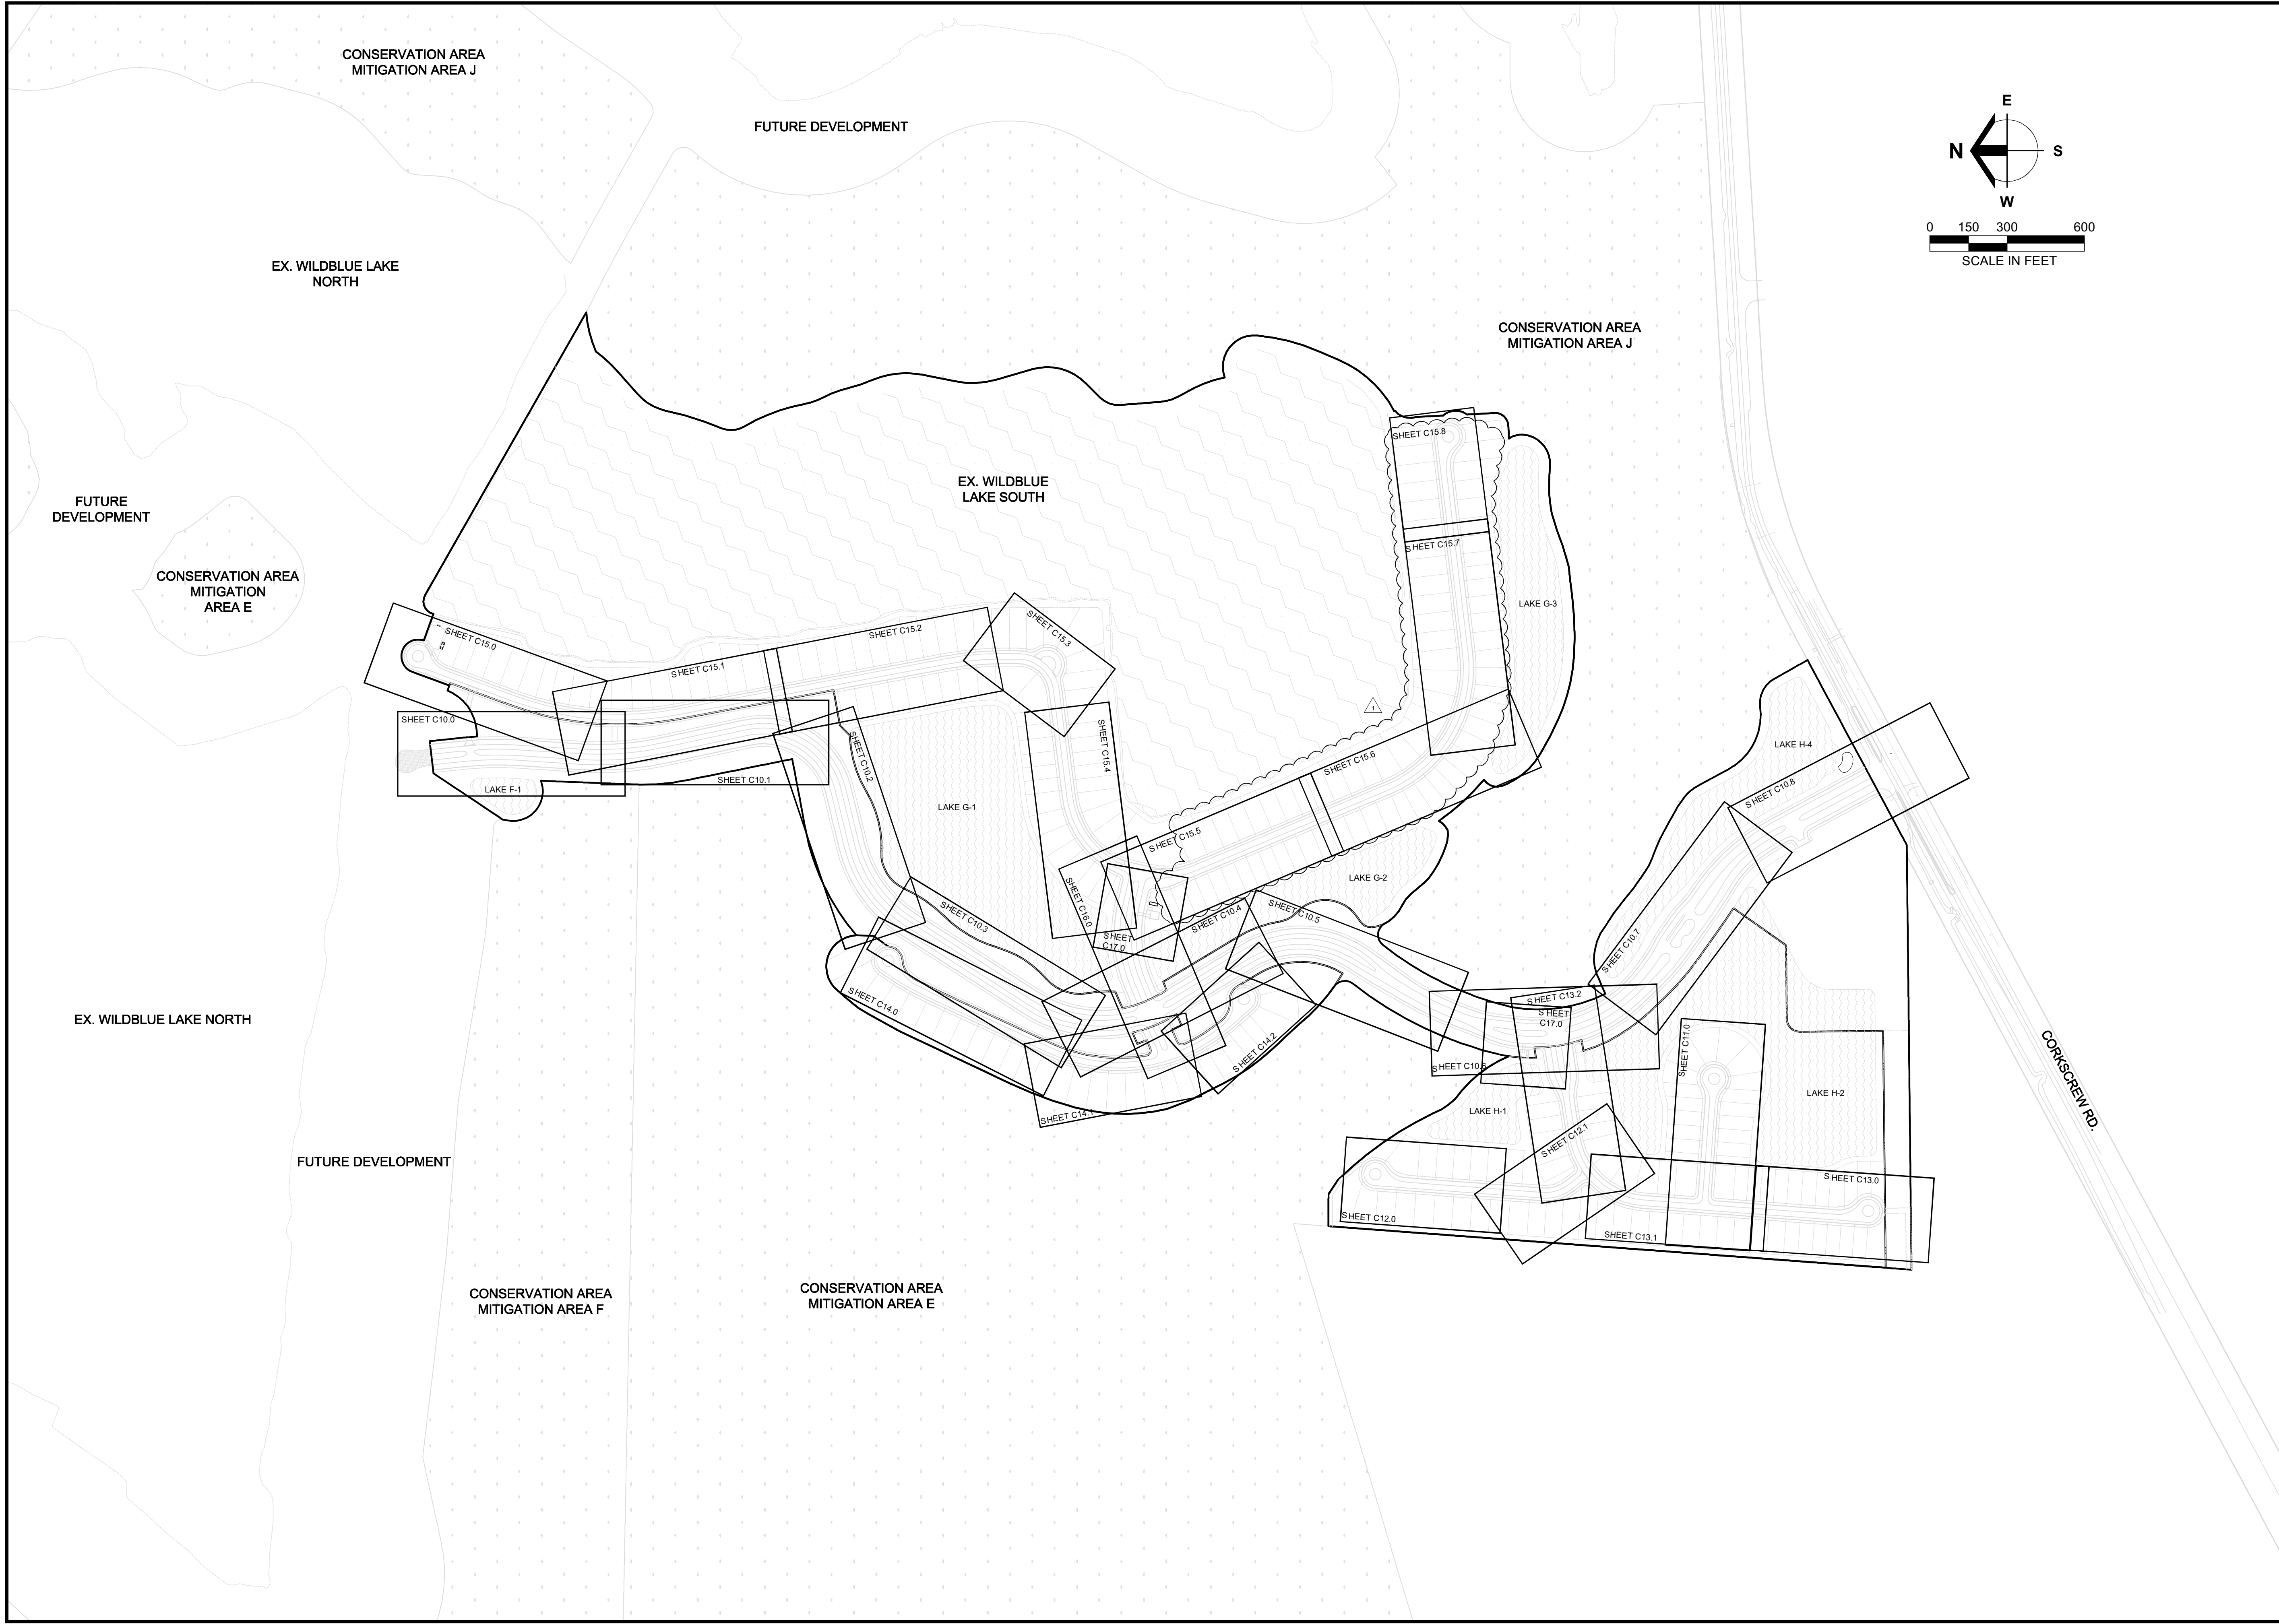

Barraco
and Associates, Inc.

CIVIL ENGINEERING - LAND SURVEYING
LAND PLANNING

www.barraco.net

2271 MCGREGOR BLVD., SUITE 100
POST OFFICE DRAWER 2800
FORT MYERS, FLORIDA 33902-2800
PHONE (239) 461-3170
FAX (239) 461-3169

FLORIDA CERTIFICATES OF AUTHORIZATION
ENGINEERING 7995 - SURVEYING LB-6940

PREPARED FOR


PULTE HOME CORPORATION
24311 WALDEN CENTER DRIVE
SUITE 300
BONITA SPRINGS, FLORIDA 34134
PHONE (239) 498-7711
FAX (239) 498-7707
WWW.PULTEHOMES.COM

PROJECT DESCRIPTION

**WILDBLUE
SOUTHWEST**

LEE COUNTY, FLORIDA

ENGINEER OF RECORD

CARL A. BARRACO, P.E. FOR THE FIRM
FLORIDA P.E. NO. 38536 - CARLB@BARRACO.NET

DRAWING NOT VALID WITHOUT SEAL, SIGNATURE AND DATE.
© COPYRIGHT 2019, BARRACO AND ASSOCIATES, INC.
REPRODUCTION, CHANGES OR ASSIGNMENTS ARE PROHIBITED

FILE NAME

J:\23526\DWG\DO SPINE ROAD\

LOCATION

J:\23526\DWG\DO SPINE ROAD\

PLOT DATE

WED. 6-5-2019 - 2:31 PM

PLOT BY

SCOTT WHEELER JR

CROSS REFERENCED DRAWINGS

PLAN REVISIONS

NO.	DATE	DESCRIPTION
06-03-19	D.O. AMENDMENT #3 CHANGES	

PLAN STATUS

D.O. AMENDMENT #3
06-05-2019



PLAN AND
PROFILE
KEY SHEET

PROJECT / FILE NO.



23526

SHEET NUMBER

C9.0

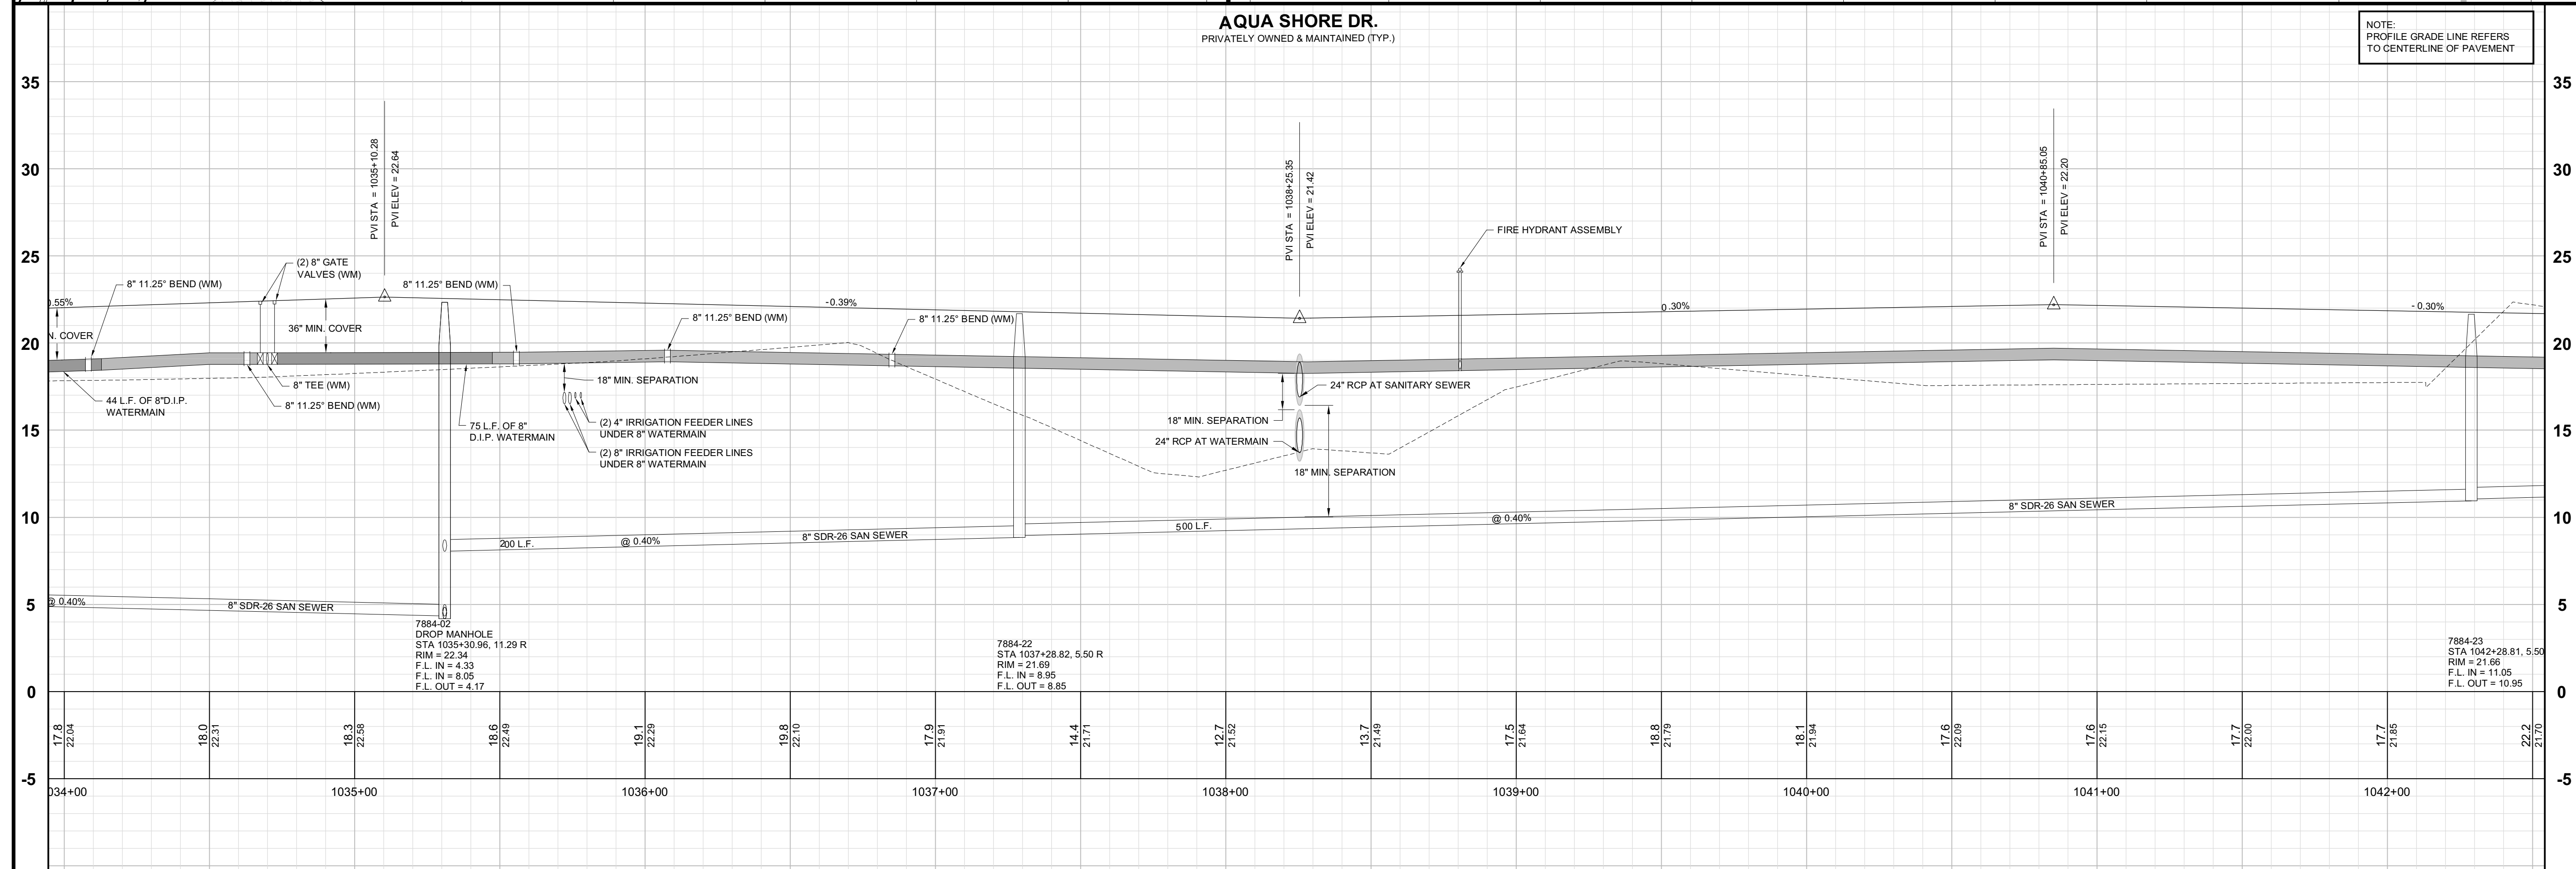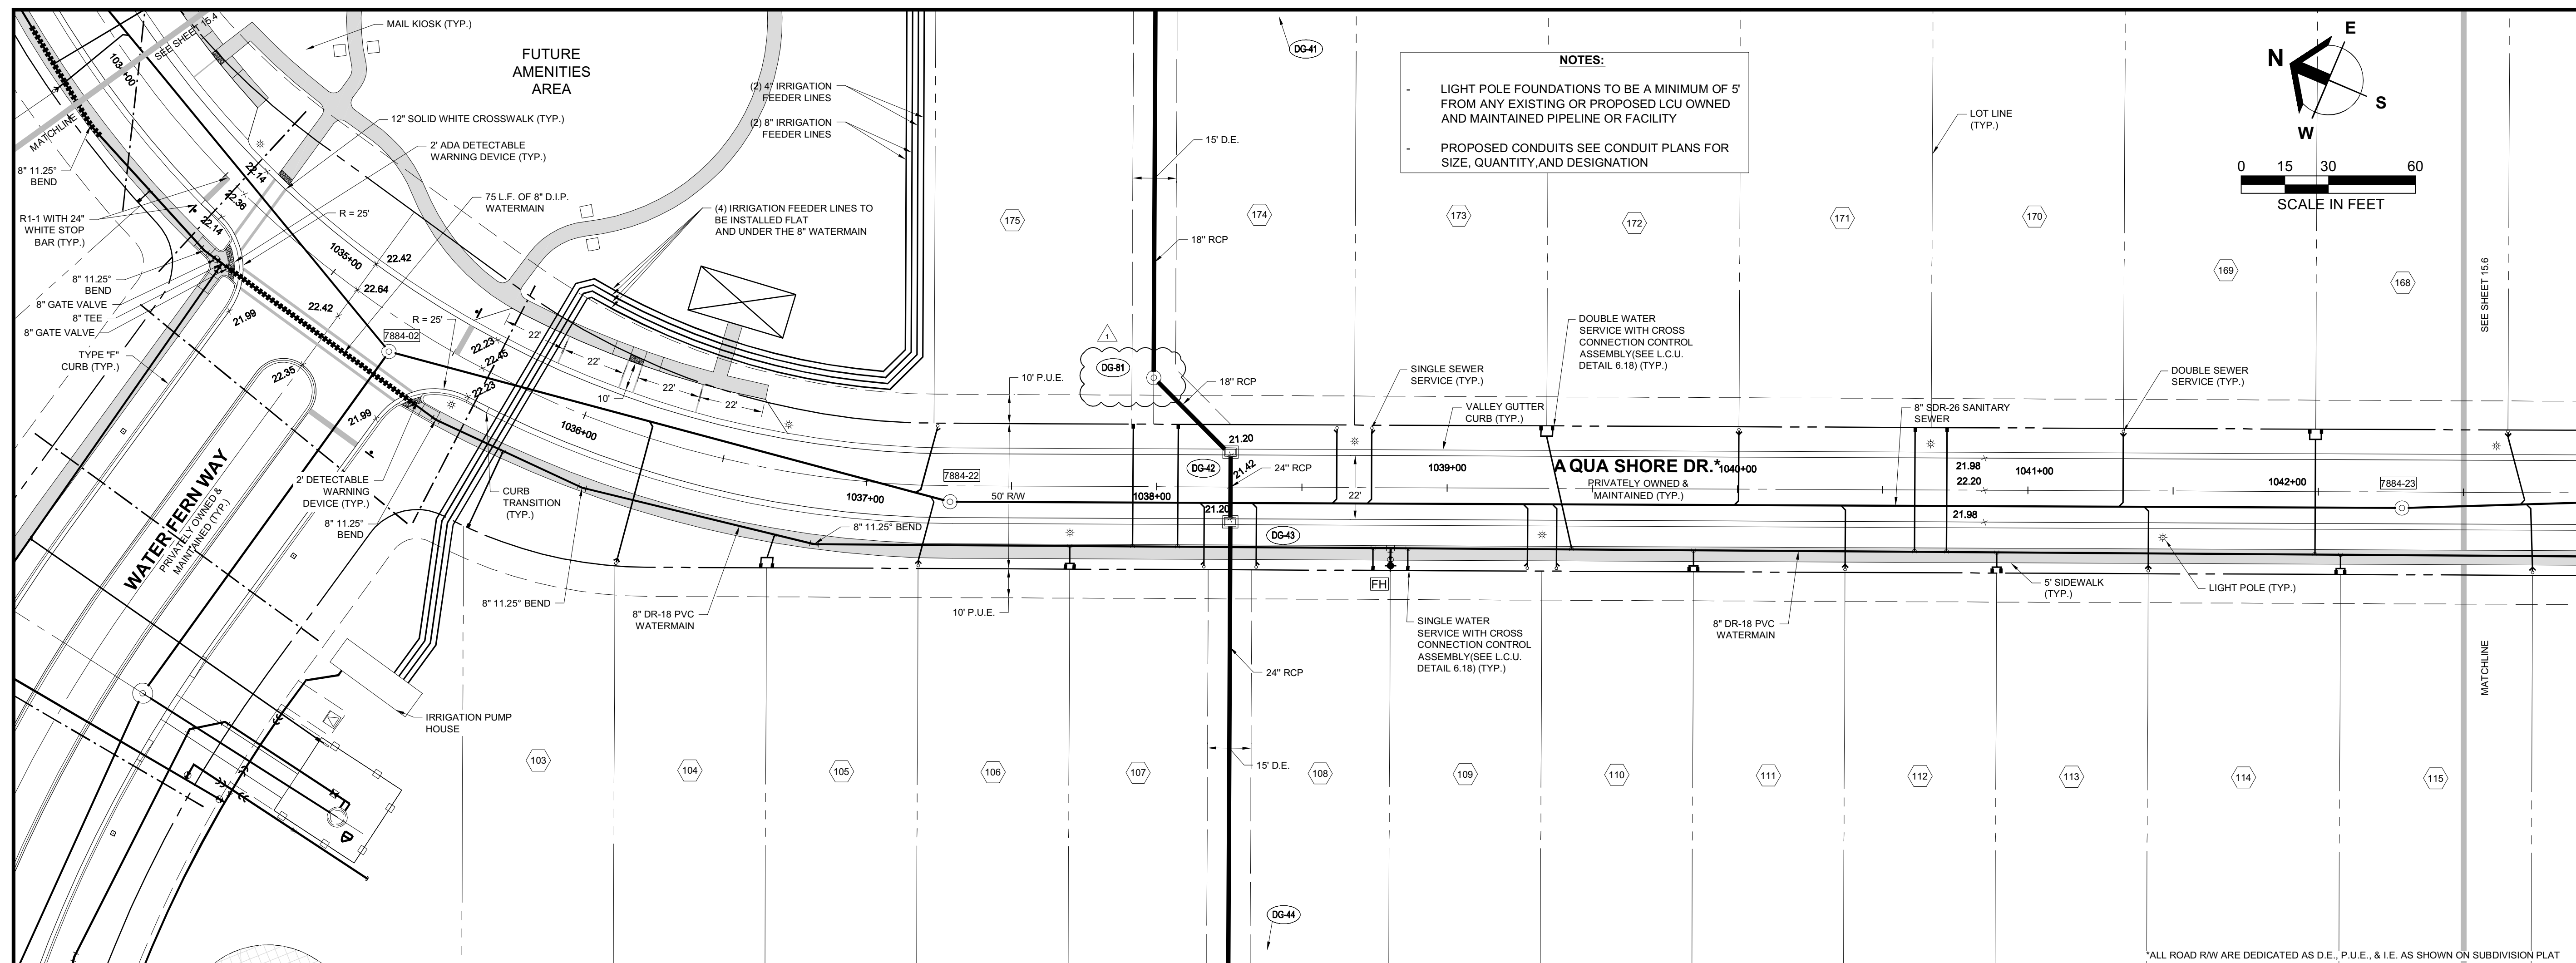

Barraco and Associates, Inc. CIVIL ENGINEERING - LAND SURVEYING LAND PLANNING www.barraco.net 2271 MCGREGOR BLVD., SUITE 100 POST OFFICE DRAWER 2800 FORT MYERS, FLORIDA 33902-2800 PHONE (239) 461-3170 FAX (239) 461-3169 FLORIDA CERTIFICATES OF AUTHORIZATION ENGINEERING 7995 - SURVEYING LB-6940	
PREPARED FOR	
 PULTE HOME CORPORATION 24311 WALDEN CENTER DRIVE SUITE 300 BONITA SPRINGS, FLORIDA 34134 PHONE (239) 498-7711 FAX (239) 498-7707 WWW.PULTEHOMES.COM	
PROJECT DESCRIPTION	
WILDBLUE SOUTHWEST	
LEE COUNTY, FLORIDA	
ENGINEER OF RECORD	
CARL A. BARRACO, P.E. FOR THE FIRM FLORIDA P.E. NO. 38536 - CARLB@BARRACONET	
DRAWING NOT VALID WITHOUT SEAL, SIGNATURE AND DATE © COPYRIGHT 2019, BARRACO AND ASSOCIATES, INC. REPRODUCTION, CHANGES OR ASSIGNMENTS ARE PROHIBITED	
FILE NAME	23526A30F.DWG
LOCATION	J:\23526\DWG\DO SPINE ROAD\
PLOT DATE	WED, 6-5-2019 - 2:32 PM
PLOT BY	SCOTT WHEELER JR
CROSS REFERENCED DRAWINGS	
BASEPLAN = 23526A00.DWG PROFILE = 23526A00P.DWG	
PLAN REVISIONS	
06-03-19	D.O. AMENDMENT #3 CHANGES 
PLAN STATUS	
D.O. AMENDMENT #3 06-05-2019	
PLAN AND PROFILE AQUA SHORE DR. STA:1034+00 TO 1042+50	
PROJECT / FILE NO.	SHEET NUMBER
23526	C15.5

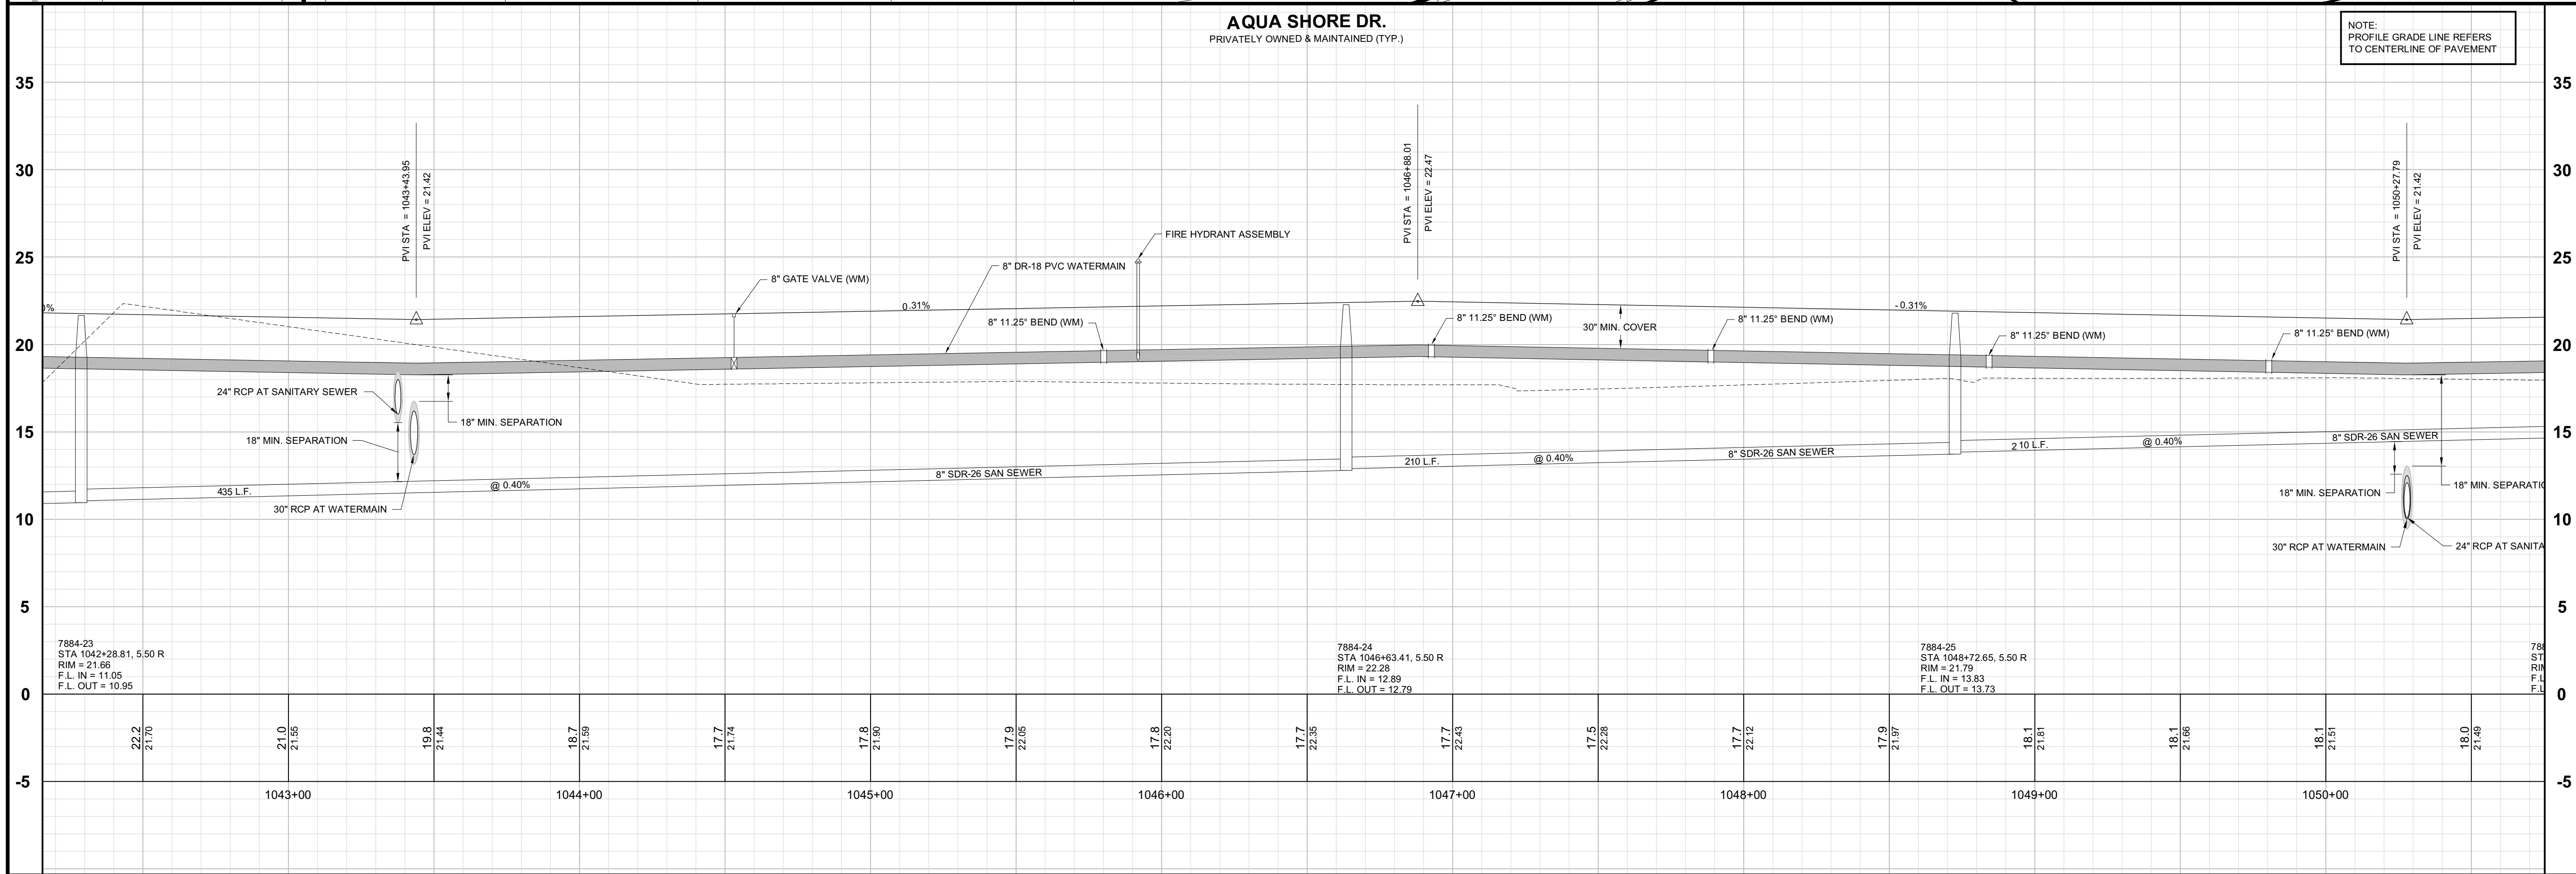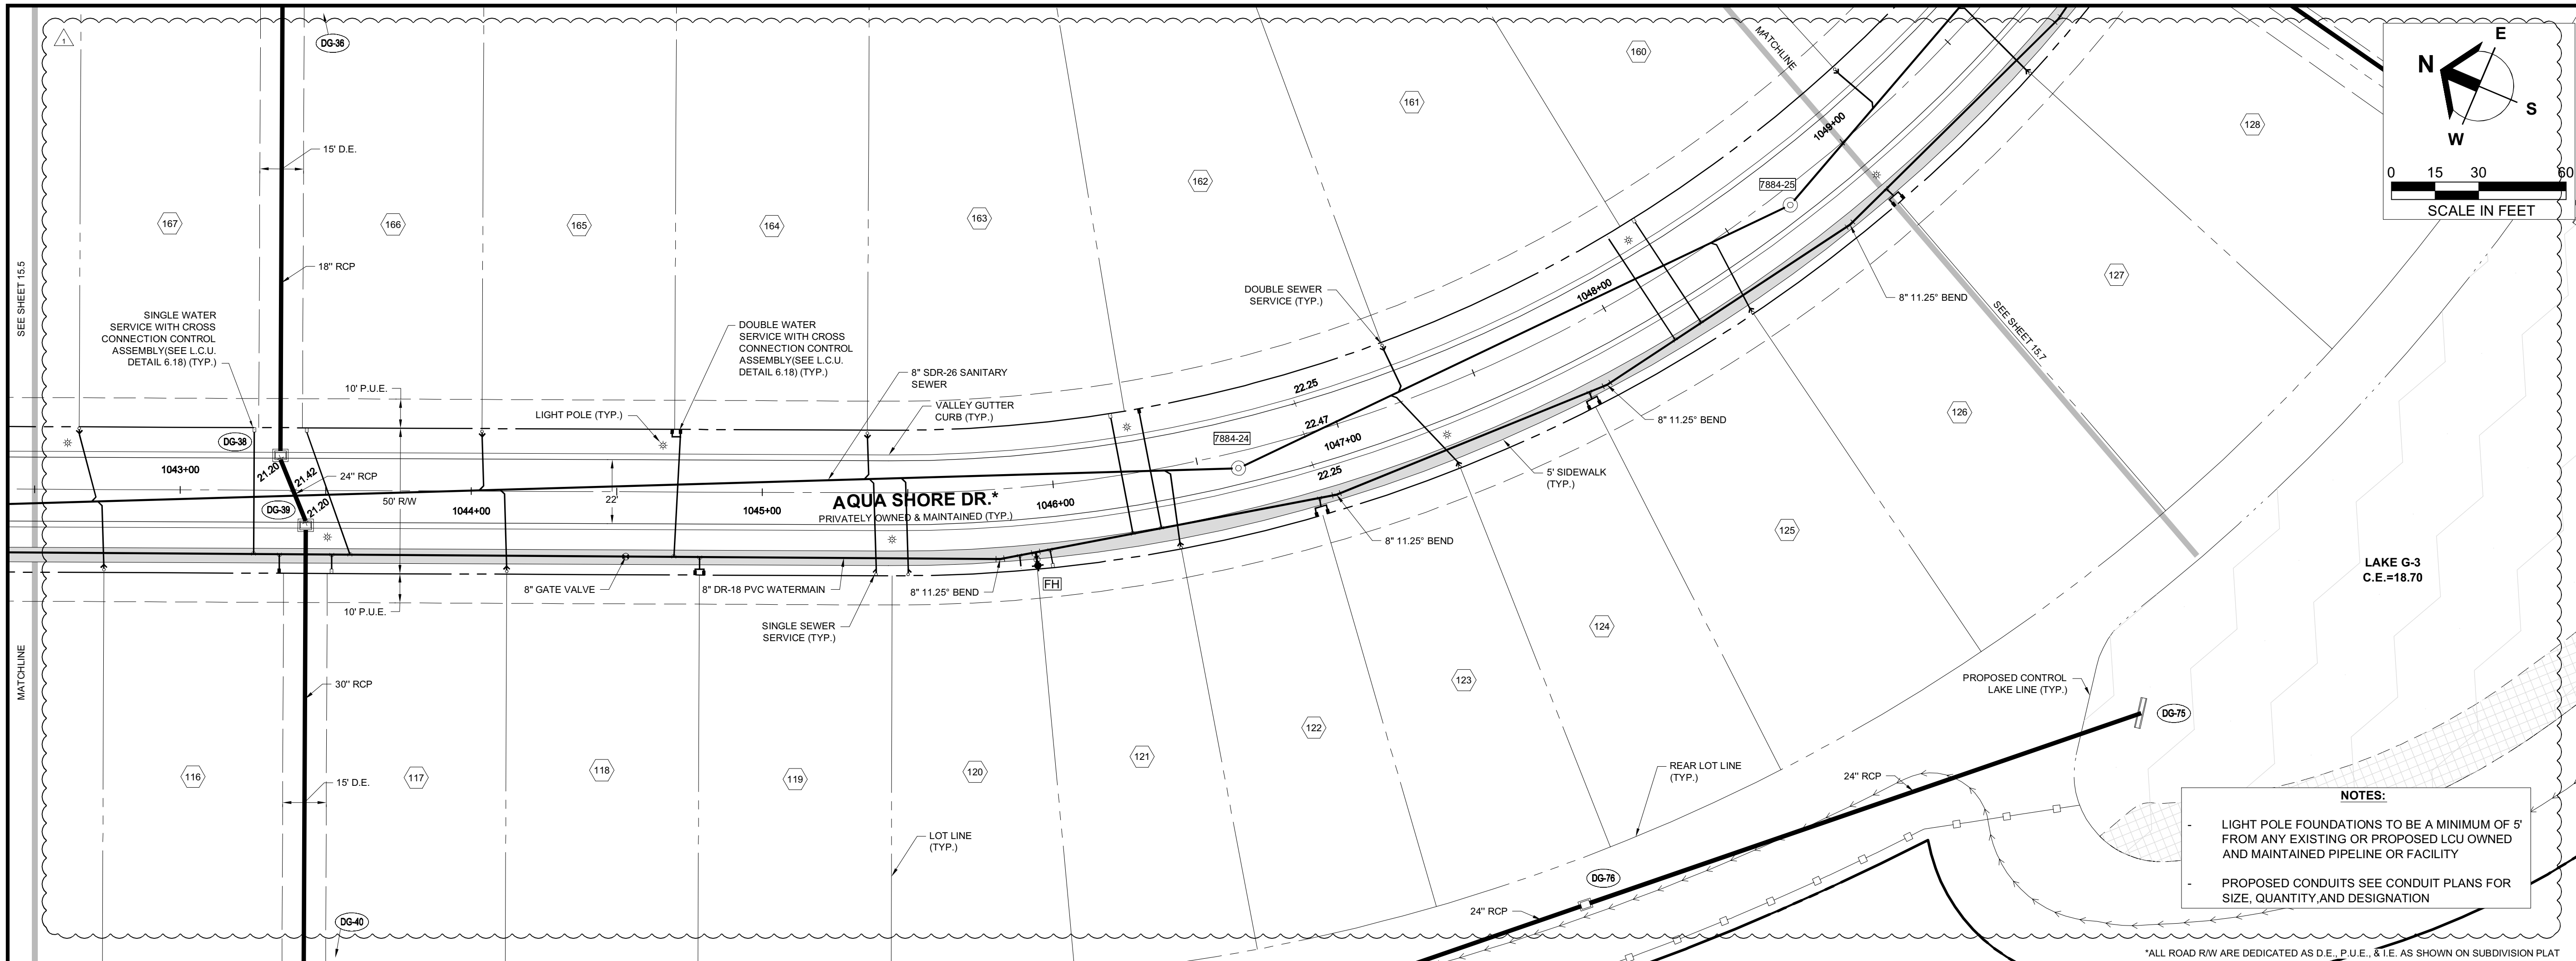



Barraco
and Associates, Inc.
CIVIL ENGINEERING - LAND SURVEYING
LAND PLANNING
www.barraco.net
2271 MCGREGOR BLVD., SUITE 100
POST OFFICE DRAWER 2800
FORT MYERS, FLORIDA 33902-2800
PHONE (239) 461-3170
FAX (239) 461-3169
FLORIDA CERTIFICATES OF AUTHORIZATION
ENGINEERING 7995 - SURVEYING LB-6940

PREPARED FOR
Pulte
Pulte Home Corporation
24311 WALDEN CENTER DRIVE
SUITE 300
BONITA SPRINGS, FLORIDA 34134
PHONE (239) 498-7711
FAX (239) 498-7707
WWW.PULTEHOMES.COM

PROJECT DESCRIPTION
**WILDBLUE
SOUTHWEST**
LEE COUNTY, FLORIDA

ENGINEER OF RECORD
CARL A. BARRACO, P.E., FOR THE FIRM
FLORIDA P.E. NO. 38536 - CARLB@BARRACO.NET

DRAWING NOT VALID WITHOUT SEAL, SIGNATURE AND DATE.
© COPYRIGHT 2019, BARRACO AND ASSOCIATES, INC.
REPRODUCTION, CHANGES OR ASSIGNMENTS ARE PROHIBITED.
FILE NAME: J:\23526\DWG\DO SPINE ROAD.DWG
LOCATION: J:\23526\DWG\DO SPINE ROAD.DWG
PLOT DATE: WED. 6-5-2019 - 2:32 PM
PLOT BY: SCOTT WHEELER JR
CROSS REFERENCED DRAWINGS
BASEPLAN = 23526A00.DWG
PROFILE = 23526A00P.DWG
PLAN REVISIONS
06-03-19 D.O. AMENDMENT #3 CHANGES
PLAN STATUS
D.O. AMENDMENT #3
06-05-2019
**PLAN AND PROFILE
AQUA SHORE DR.
STA: 1042+50 TO 1049+00**
PROJECT / FILE NO. **23526**
SHEET NUMBER **C15.6**

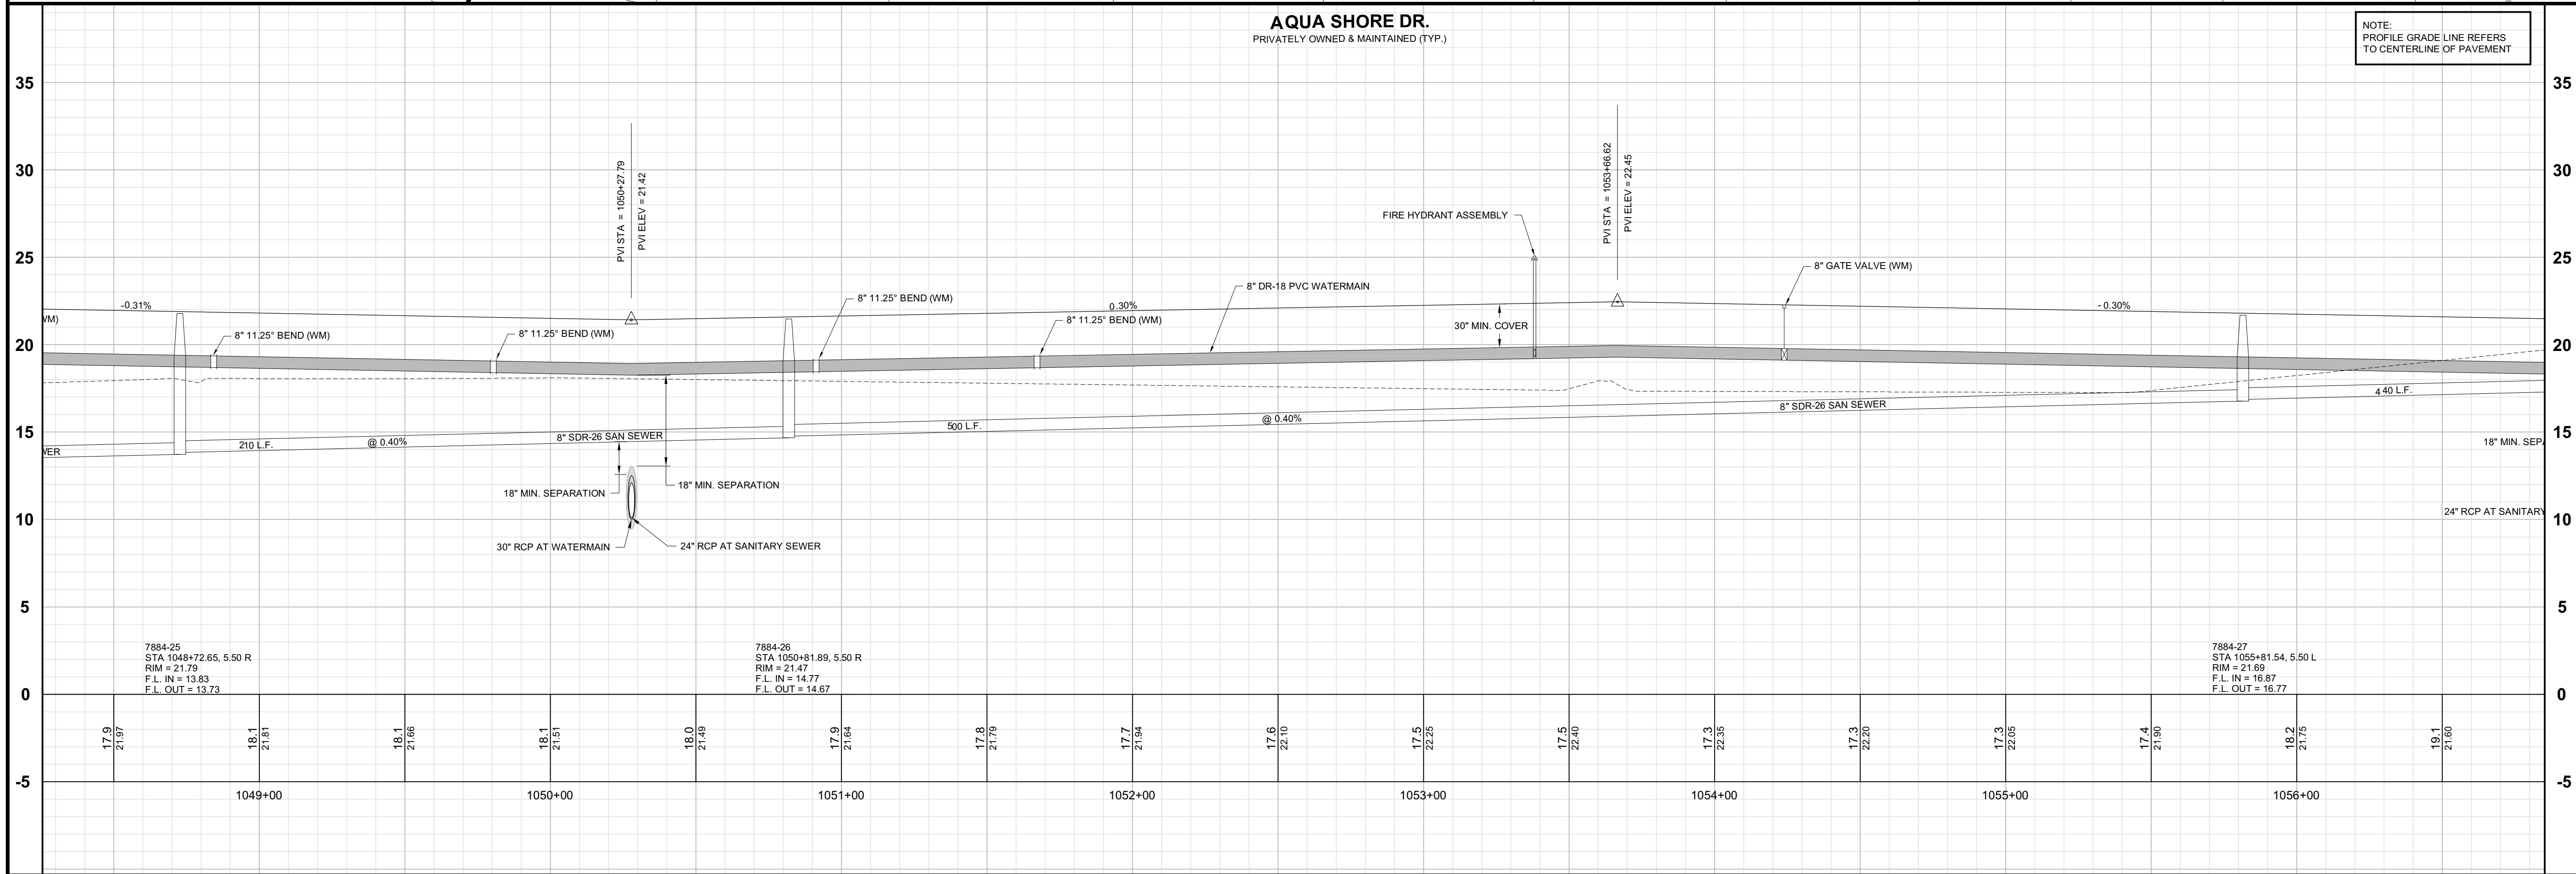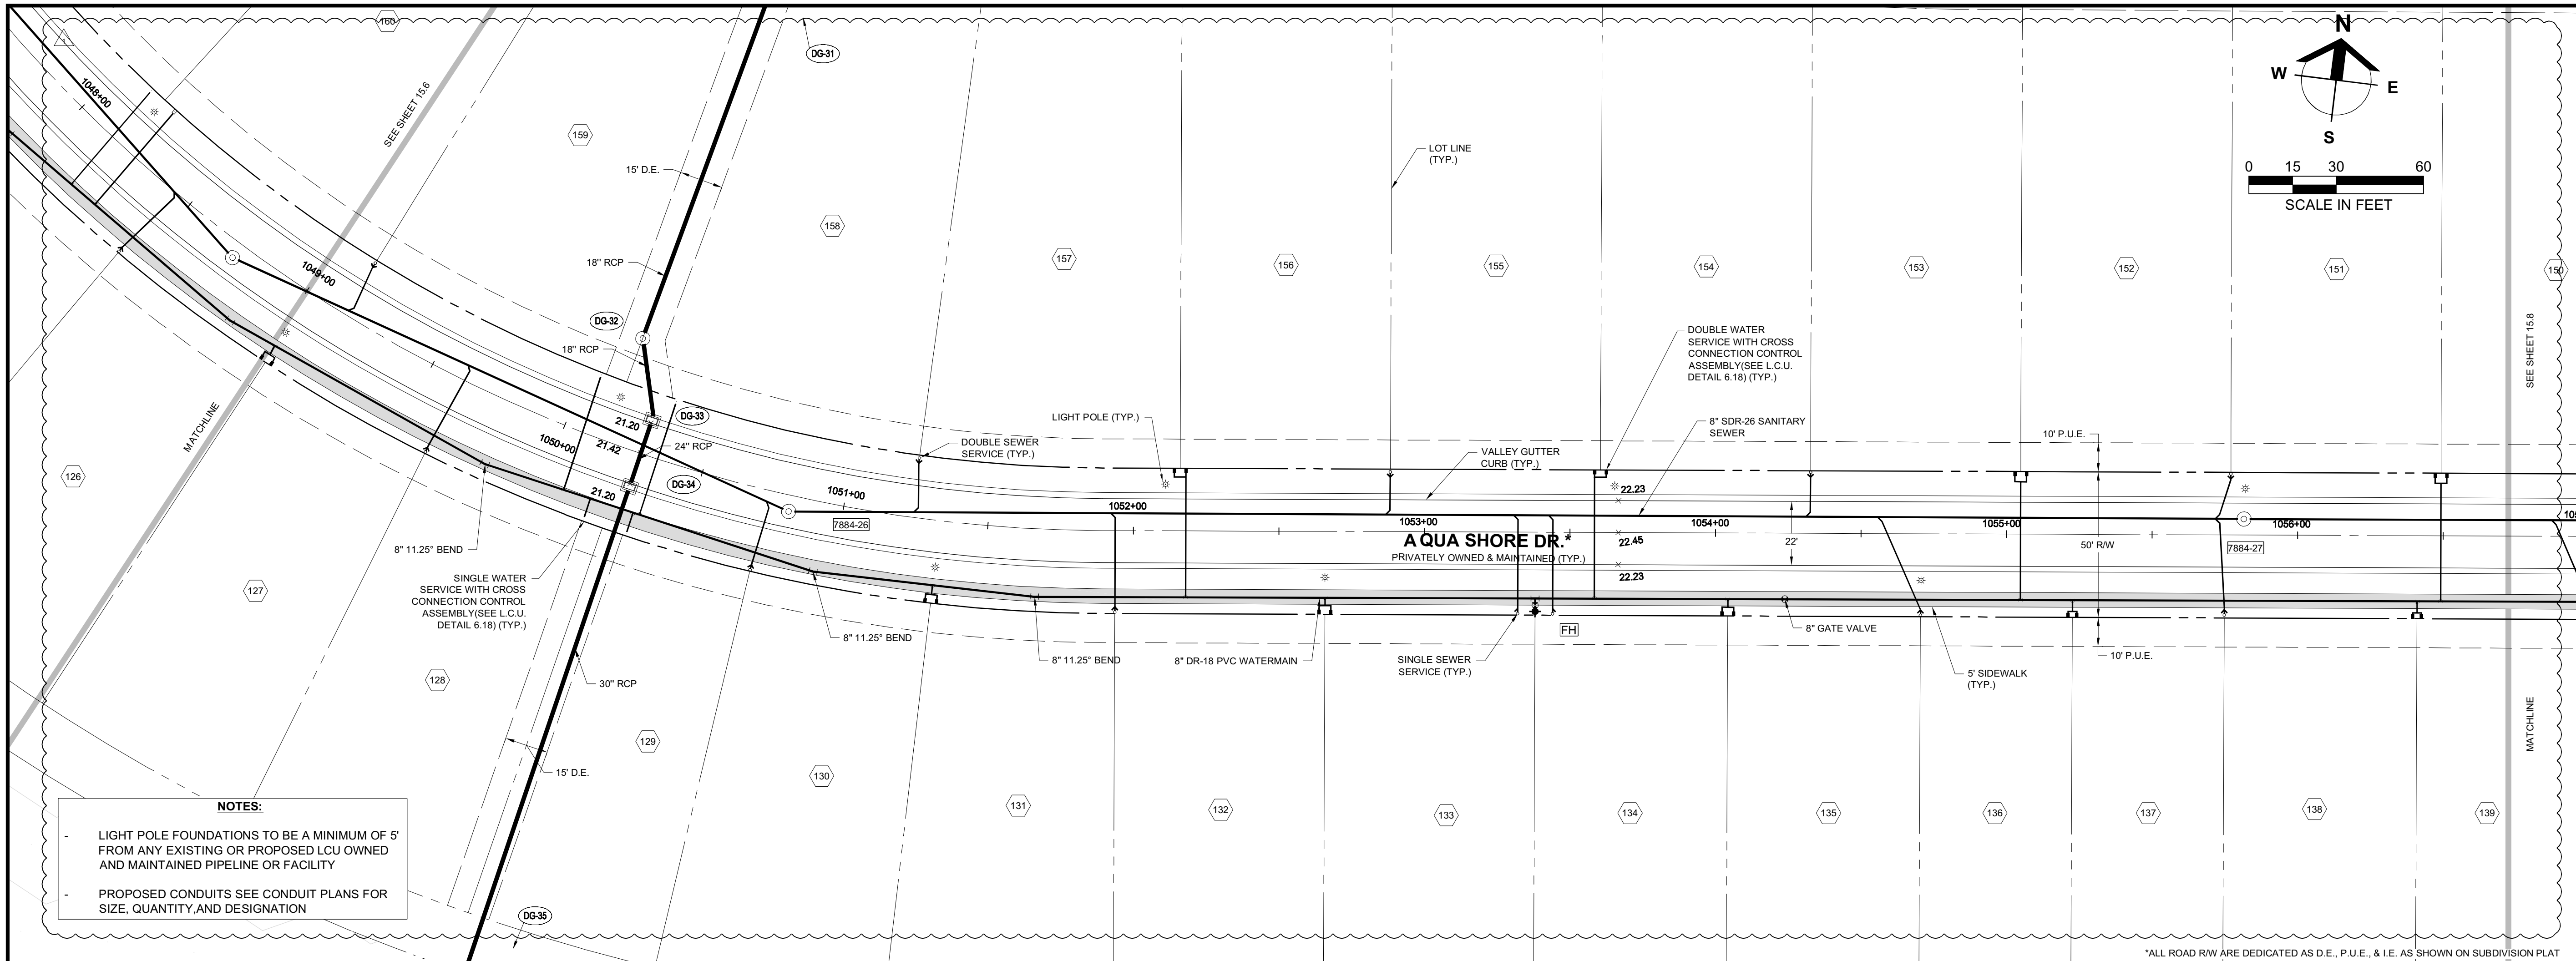

Barraco
and Associates, Inc.
CIVIL ENGINEERING - LAND SURVEYING
LAND PLANNING
www.barraco.net
2271 MCGREGOR BLVD., SUITE 100
POST OFFICE DRAWER 2800
FORT MYERS, FLORIDA 33902-2800
PHONE (239) 461-3170
FAX (239) 461-3169
FLORIDA CERTIFICATES OF AUTHORIZATION
ENGINEERING 7995 - SURVEYING LB-6940

PREPARED FOR

PULTE HOME CORPORATION
24311 WALDEN CENTER DRIVE
SUITE 300
BONITA SPRINGS, FLORIDA 34134
PHONE (239) 498-7711
FAX (239) 498-7707
WWW.PULTEHOMES.COM

PROJECT DESCRIPTION

**WILDBLUE
SOUTHWEST**

LEE COUNTY, FLORIDA

ENGINEER OF RECORD
CARL A. BARRACO, P.E., FOR THE FIRM
FLORIDA P.E. NO. 38536 - CARLB@BARRACO.NET

DRAWING NOT VALID WITHOUT SEAL, SIGNATURE AND DATE.
© COPYRIGHT 2019, BARRACO AND ASSOCIATES, INC.
REPRODUCTION, CHANGES OR ASSIGNMENTS ARE PROHIBITED.

FILE NAME J:\23526\DWG\DO SPINE ROAD\

PLOT DATE WED, 6-5-2019 - 2:32 PM

PLOT BY SCOTT WHEELER JR

CROSS REFERENCED DRAWINGS
BASEPLAN = 23526A00.DWG
PROFILE = 23526A00P.DWG



PLAN REVISIONS
06-03-19 D.O. AMENDMENT #3 CHANGES

PLAN STATUS
D.O. AMENDMENT #3
06-05-2019

**PLAN AND PROFILE
AQUA SHORE DR.
STA:1049+00 TO 1056+70**


PROJECT / FILE NO. **23526**

SHEET NUMBER **C15.7**

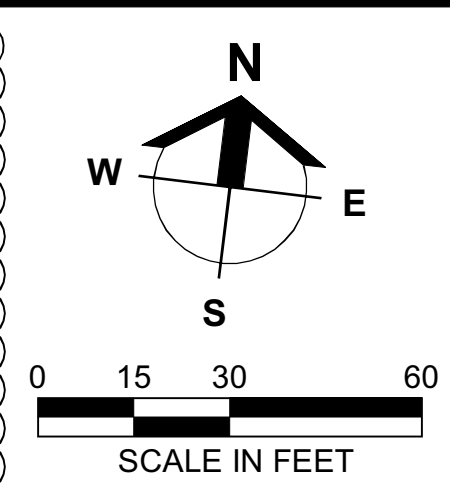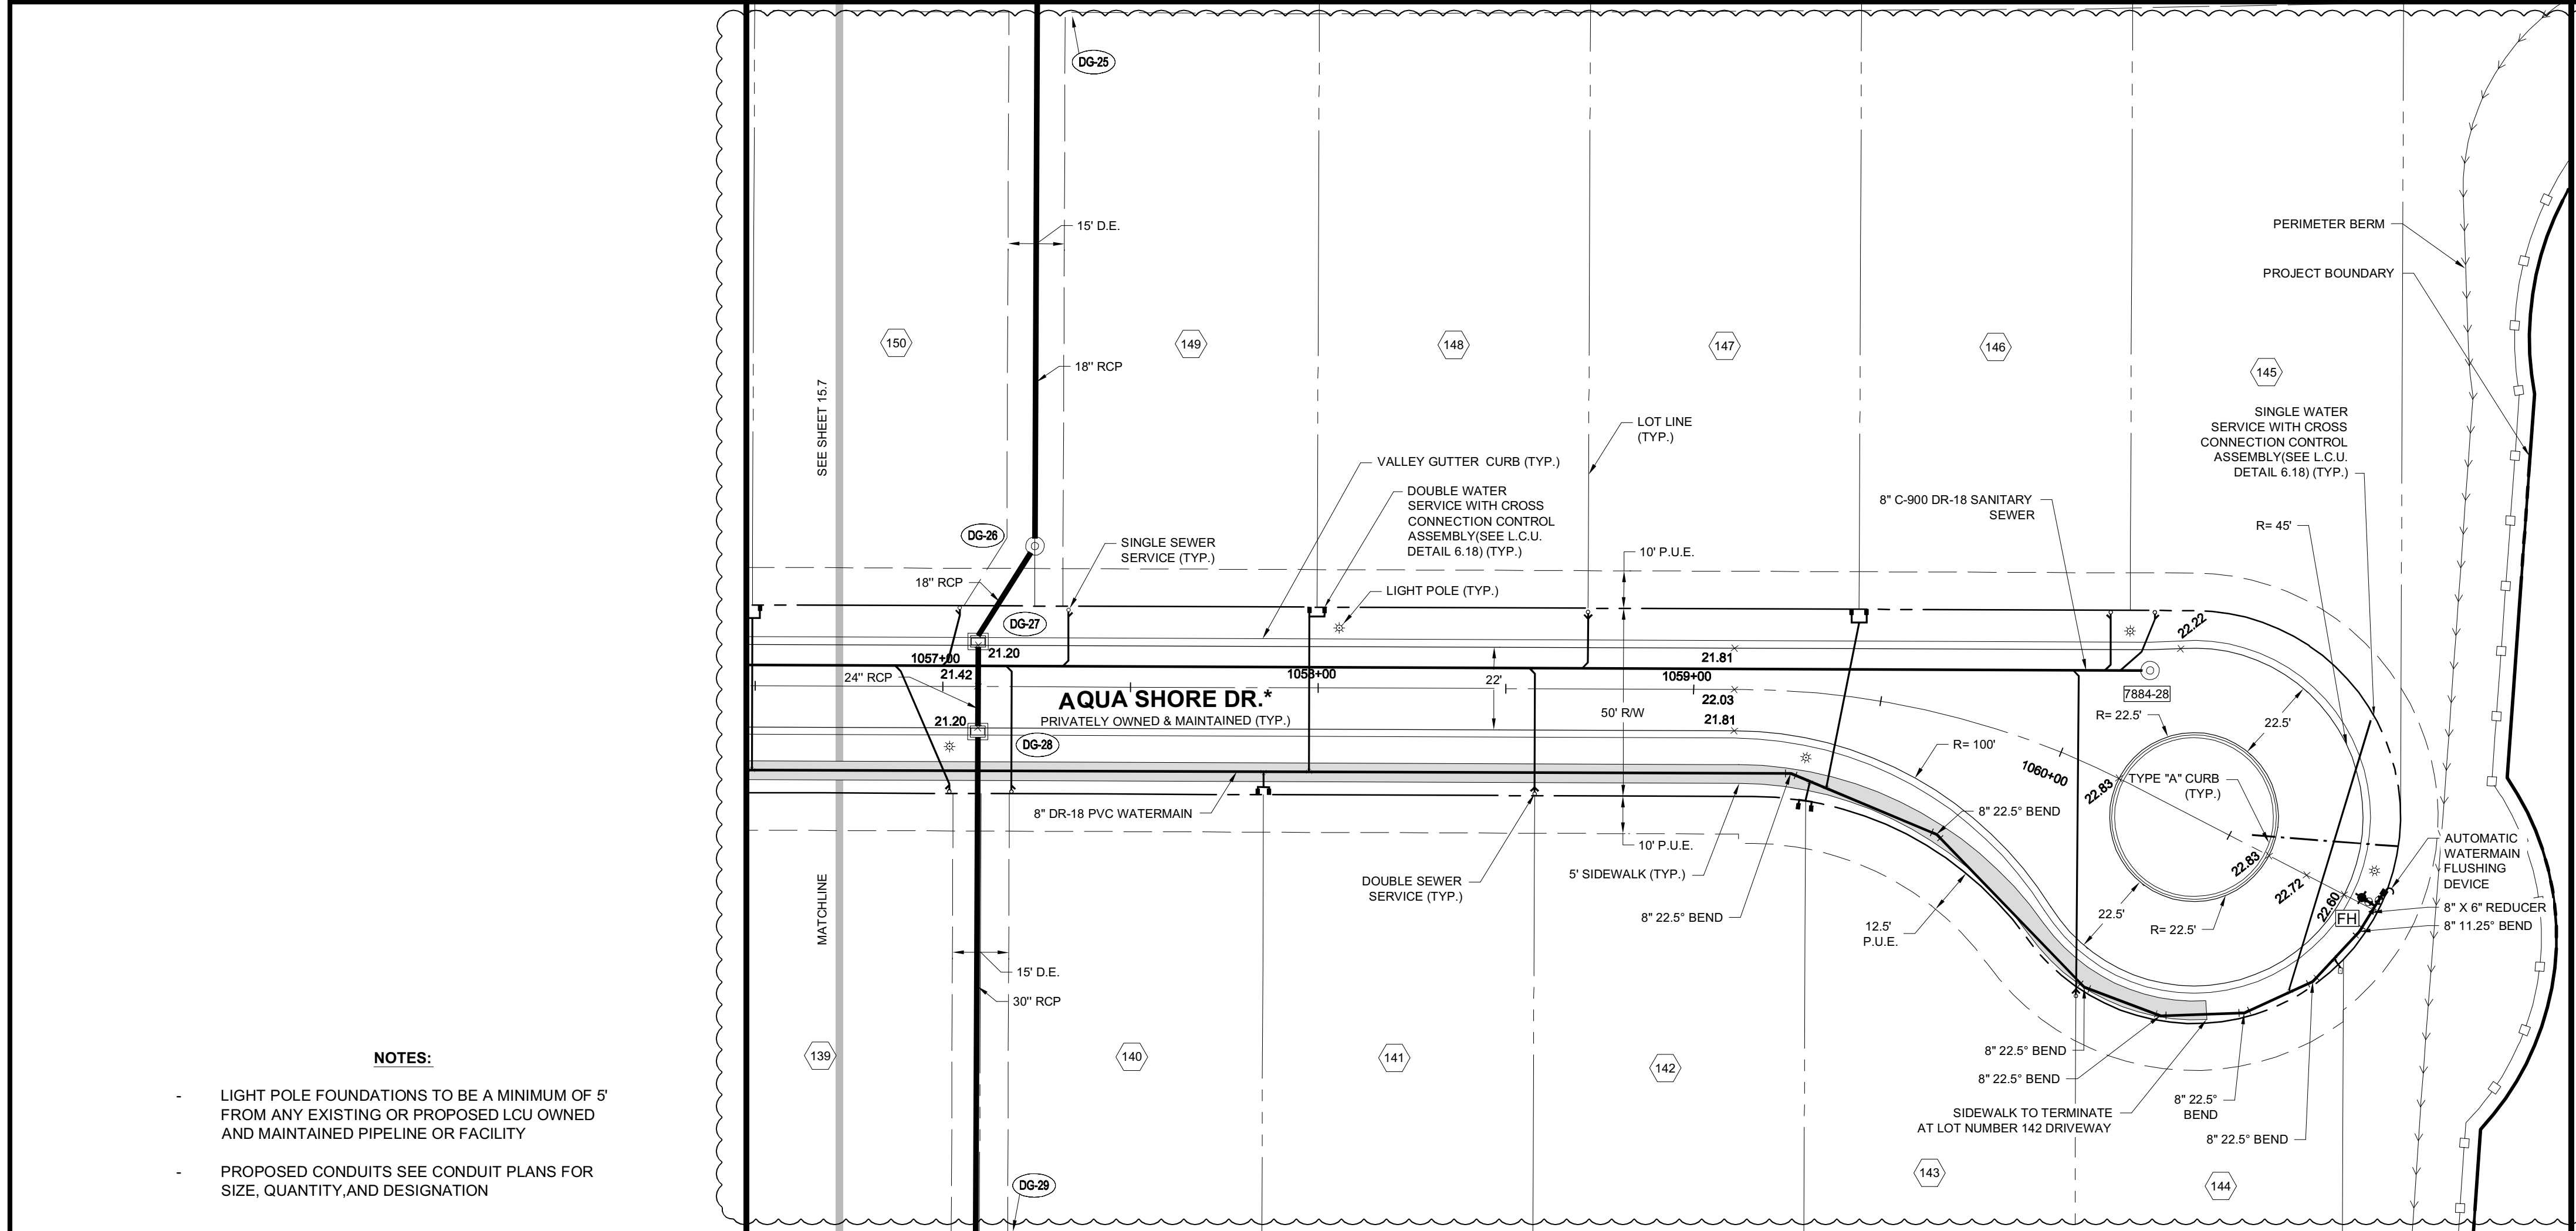

- NOTES:**
- LIGHT POLE FOUNDATIONS TO BE A MINIMUM OF 5' FROM ANY EXISTING OR PROPOSED LCU OWNED AND MAINTAINED PIPELINE OR FACILITY
 - PROPOSED CONDUITS SEE CONDUIT PLANS FOR SIZE, QUANTITY, AND DESIGNATION

*ALL ROAD R/W ARE DEDICATED AS D.E., P.U.E., & I.E. AS SHOWN ON SUBDIVISION PLAT

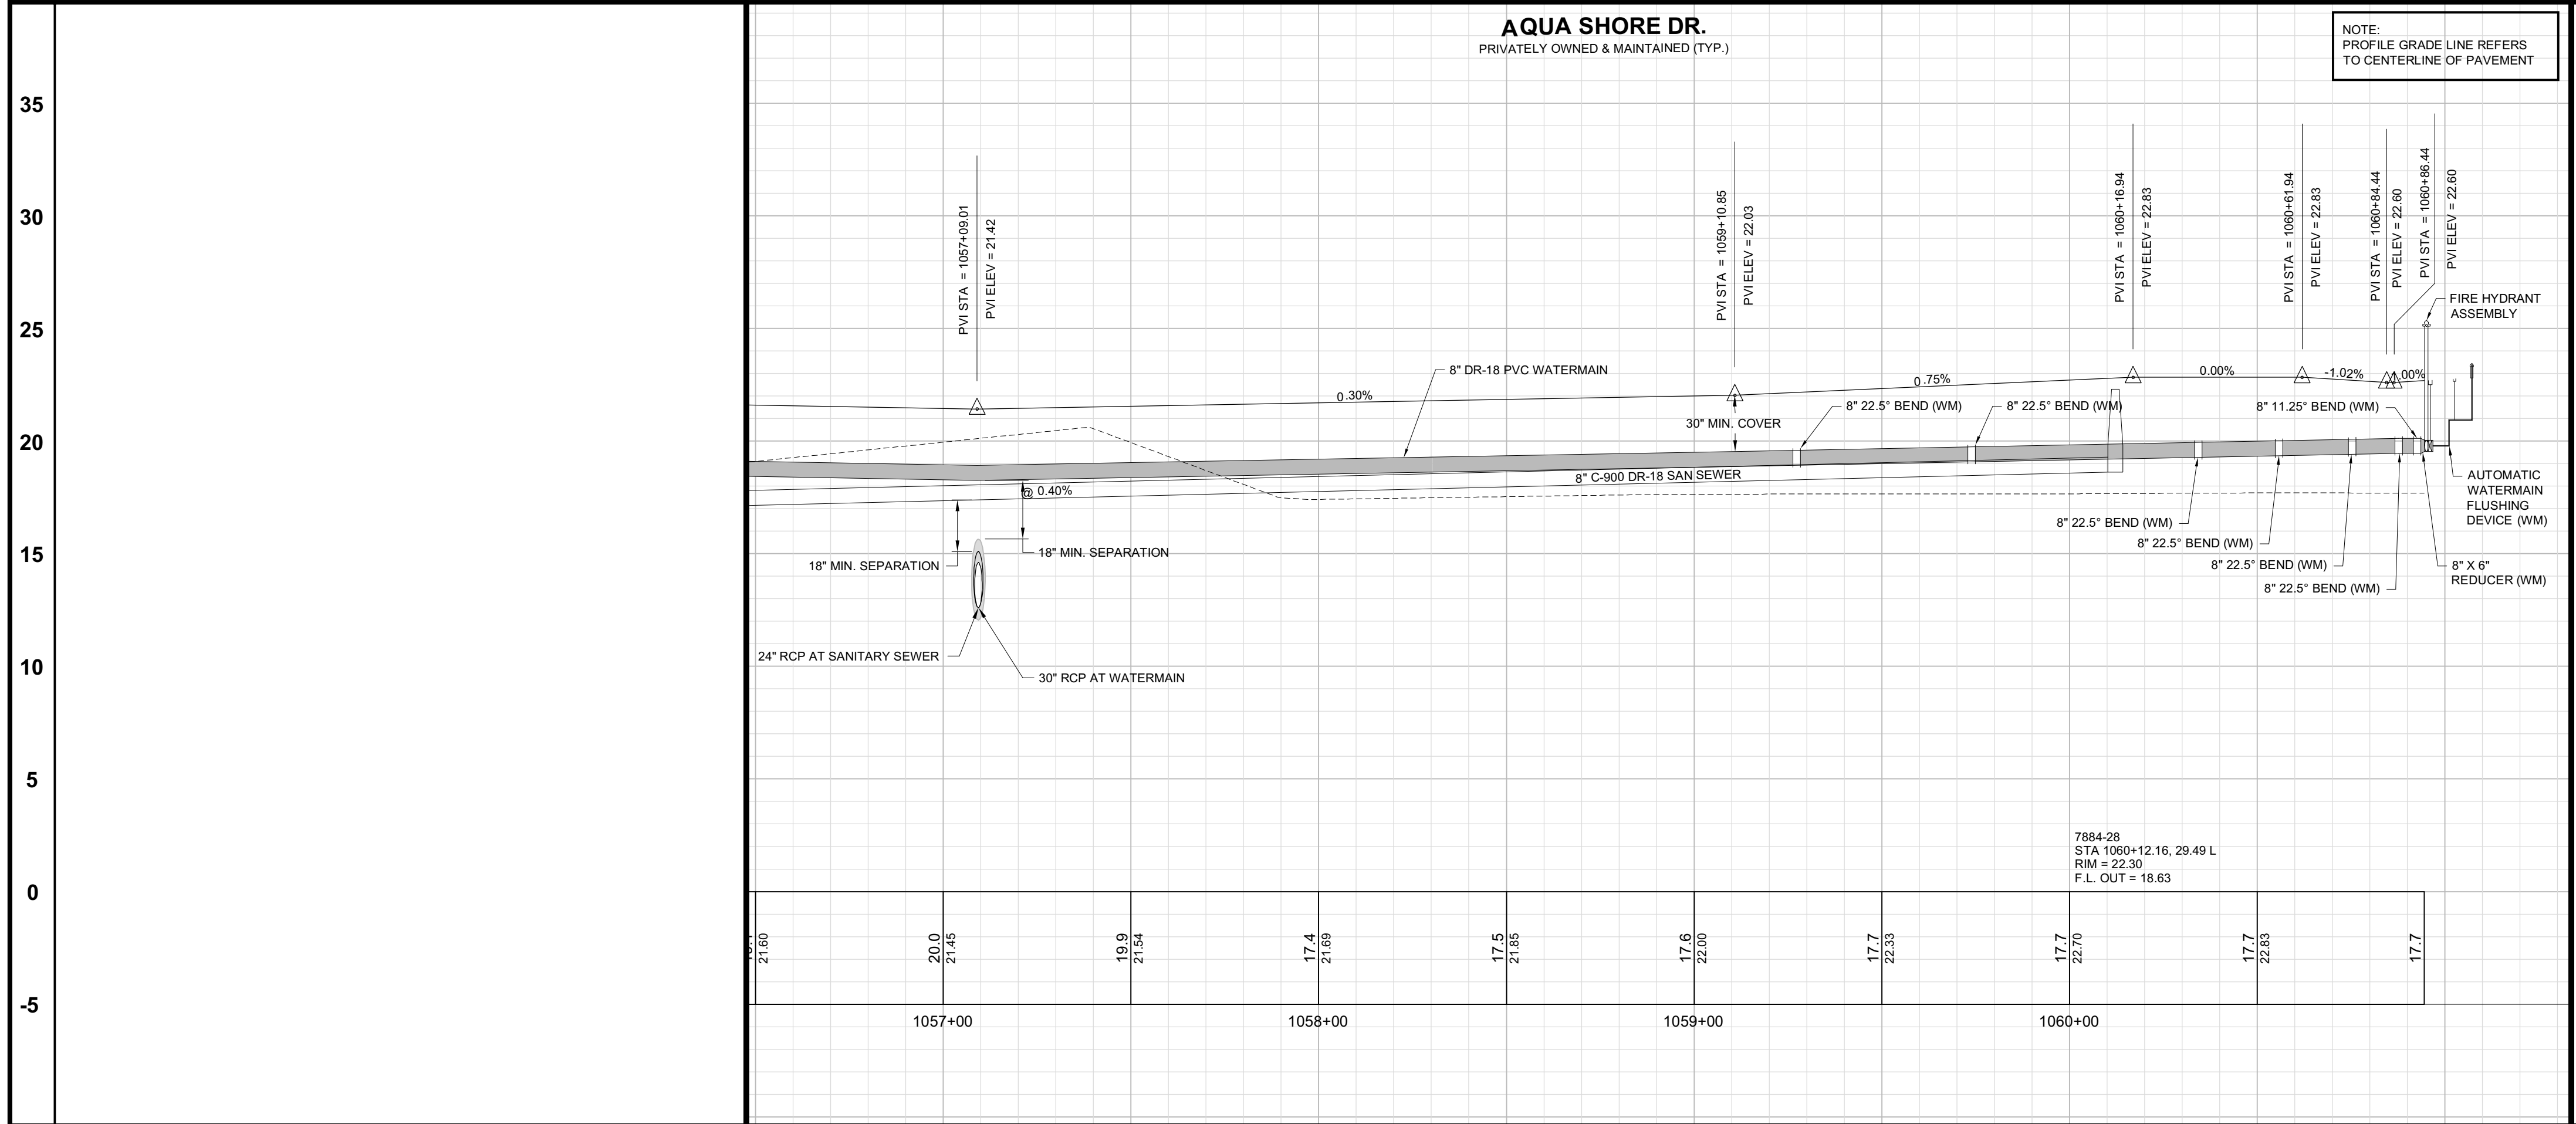

NOTE:
PROFILE GRADE LINE REFERS
TO CENTERLINE OF PAVEMENT

Barraco
and Associates, Inc.
CIVIL ENGINEERING - LAND SURVEYING
LAND PLANNING
www.barraco.net
2271 MCGREGOR BLVD., SUITE 100
POST OFFICE DRAWER 2800
FORT MYERS, FLORIDA 33902-2800
PHONE (239) 461-3170
FAX (239) 461-3169
FLORIDA CERTIFICATES OF AUTHORIZATION
ENGINEERING 7995 - SURVEYING LB-6940

PREPARED FOR
Pulte
Homes
PULTE HOME CORPORATION
24311 WALDEN CENTER DRIVE
SUITE 300
BONITA SPRINGS, FLORIDA 34134
PHONE (239) 498-7711
FAX (239) 498-7707
WWW.PULTEHOMES.COM

PROJECT DESCRIPTION
**WILDBLUE
SOUTHWEST**
LEE COUNTY, FLORIDA

ENGINEER OF RECORD
CARL A. BARRACO, P.E. FOR THE FIRM
FLORIDA P.E. NO. 38536 - CARLB@BARRACO.NET

DRAWING NOT VALID WITHOUT SEAL, SIGNATURE AND DATE.
© COPYRIGHT 2019, BARRACO AND ASSOCIATES, INC.
REPRODUCTION, CHANGES OR ASSIGNMENTS ARE PROHIBITED.

FILE NAME J:\23526\DWG\DO SPINE ROAD\DWG
LOCATION J:\23526\DWG\DO SPINE ROAD\DWG
PLOT DATE WED. 6-5-2019 - 2:32 PM
PLOT BY SCOTT WHEELER JR

CROSS REFERENCED DRAWINGS
BASEPLAN = 23526A00.DWG
PROFILE = 23526A00P.DWG

PLAN REVISIONS
06-03-19 D.O. AMENDMENT #3 CHANGES

PLAN STATUS
D.O. AMENDMENT #3
06-05-2019

PLAN AND PROFILE
AQUA SHORE DR.
STA:1056+70 TO END

PROJECT / FILE NO. 23526
SHEET NUMBER C15.8

LOT DIMENSIONS TABLE

LOT #	WIDTH (')	DEPTH (')	AREA (SF)
MIN.	50	100	5,000
1	66.2	164.5	10,777
2	55.2	173.4	9,572
3	69.2	181.8	12,578
4	72.2	191.3	13,810
5	72.7	175.8	12,811
6	73.1	162.3	11,258
7	57.6	166.8	9,105
8	73.1	168.0	11,621
9	79.8	165.3	12,525
10	83.1	168.3	13,228
11	83.1	169.6	13,377
12	79.8	166.5	12,637
13	80.3	159.3	12,108
14	72.2	160.3	11,672
15	72.2	211.8	14,917
16	72.2	219.2	15,662
17	72.2	202.0	14,585
18	72.2	184.6	13,338
19	75.2	174.4	13,113
20	75.2	168.3	12,606
21	72.2	165.2	11,924
22	72.2	164.1	11,844
23	66.2	163.0	10,790
24	66.2	162.0	10,722
25	66.2	164.9	10,928
26	66.2	176.2	11,667
27	66.2	178.2	11,777
28	66.2	163.8	10,884
29	69.4	159.1	11,466
30	69.2	157.3	11,391
31	66.3	159.7	11,077
32	66.2	165.8	11,221
33	66.4	167.5	11,125
34	66.2	169.4	11,081
35	61.9	162.4	10,381
36	60.5	230.0	22,968
37	67.9	161.5	13,073
38	66.2	176.9	11,614
39	66.2	174.4	11,546
40	66.2	173.8	11,505
41	55.2	173.2	9,562
42	55.2	172.7	9,534
43	52.2	172.2	8,990
44	52.2	171.7	8,965
45	52.2	171.3	8,940
46	75.4	170.4	10,572
47	85.8	172.4	11,121
48	93.9	185.1	12,776
49	52.2	140.0	8,164
50	52.2	140.0	8,164
51	69.1	140.0	10,813
52	55.2	140.0	8,639
53	66.1	140.0	10,338
54	66.1	144.8	10,338
55	72.2	140.1	10,820
56	52.2	140.0	7,308
57	52.2	140.0	7,308
58	52.2	140.0	7,308
59	55.2	140.0	7,728
60	55.2	140.0	7,728
61	52.2	140.5	7,386
62	40.0	166.2	15,648
63	159.2	162.9	18,098
64	73.2	140.0	9,846
65	76.5	140.0	10,272
66	72.9	140.0	9,981
67	66.2	140.0	9,268
68	66.2	140.0	9,268
69	66.2	140.0	9,268
70	66.2	140.0	9,268
71	66.2	140.0	9,268
72	66.2	140.0	9,268
73	101.1	220.3	18,076
74	68.0	169.6	16,276
75	72.2	160.1	12,090
76	72.2	156.2	11,796
77	75.3	155.9	12,234
78	75.3	155.5	11,814
79	72.2	156.2	11,278
80	72.2	156.9	11,328
81	72.2	157.7	11,378
82	72.2	158.3	11,428
83	66.2	159.0	10,523
84	66.2	159.2	10,531
85	66.2	157.0	11,084
86	69.2	156.5	11,704
87	69.2	159.7	11,957
88	66.2	163.9	11,758
89	66.2	166.9	11,996

LOT #	WIDTH (')	DEPTH (')	AREA (SF)
MIN.	50	100	5,000
90	66.2	168.7	12,141
91	66.2	169.3	12,191
92	52.2	165.2	9,382
93	52.2	161.4	9,094
94	52.2	155.9	8,797
95	52.2	155.0	8,738
96	52.2	157.5	8,882
97	55.3	160.2	9,577
98	55.2	162.9	9,397
99	55.2	164.2	8,568
100	56.1	166.0	13,802
101	54.6	156.0	14,520
102	54.0	150.3	9,149
103	53.7	144.8	7,595
104	52.2	140.0	7,309
105	52.2	140.0	7,308
106	52.0	140.0	7,308
107	55.2	140.0	7,728
108	55.2	140.0	7,728
109	52.2	140.0	7,308
110	52.2	140.0	7,308
111	52.2	140.0	7,308
112	52.2	140.0	7,308
113	52.2	140.0	7,308
114	66.2	140.0	9,268
115	66.2	140.0	9,268
116	69.2	140.0	9,688
117	69.2	140.0	9,688
118	66.2	140.0	9,268
119	66.2	140.0	9,289
120	52.2	140.0	7,927
121	52.2	140.0	7,927
122	52.2	140.0	7,927
123	52.2	140.0	7,927
124	53.2	140.0	8,072
125	65.9	140.0	10,009
126	65.9	140.0	10,009
127	65.9	140.0	10,009
128	69.0	140.0	10,405
129	55.2	140.0	8,383
130	65.9	140.0	10,009
131	66.0	140.0	9,977
132	72.2	140.0	10,108
133	72.2	140.0	10,108
134	66.2	140.0	9,268
135	66.2	140.0	9,268
136	52.2	140.0	7,308
137	52.2	140.0	7,308
138	66.2	140.0	9,268
139	69.2	140.0	9,688
140	75.2	140.0	10,550
141	72.2	151.6	11,011
142	72.3	189.7	13,843
143	90.7	193.2	13,838
144	74.2	154.1	11,265
145	78.2	178.1	12,732
146	72.2	165.9	11,981
147	72.2	165.2	11,925
148	72.2	164.4	11,869
149	75.2	164.1	12,340
150	75.2	164.3	12,353
151	72.2	164.4	11,873
152	72.2	164.6	11,884
153	72.2	164.9	11,935
154	72.2	169.8	12,259
155	72.2	175.2	12,652
156	72.2	180.6	13,045
157	86.6	185.9	14,356
158	99.0	182.1	15,297
159	91.0	165.7	13,214
160	87.1	163.9	12,392
161	87.1	156.6	12,117
162	87.1	173.6	12,971
163	84.7	181.2	13,242
164	66.2	179.3	11,871
165	66.2	176.5	11,686
166	69.2	173.7	12,019
167	69.2	170.8	11,818
168	66.2	167.9	11,117
169	66.2	165.4	10,941
170	66.2	164.9	10,918
171	66.2	165.6	10,962
172	66.2	166.3	11,006
173	66.2	166.9	11,050
174	69.2	170.9	11,838
175	75.6	182.1	13,763
176	137.3	157.3	15,614
177	69.2	140.0	9,712
178	66.2	140.0	9,268

LOT #	WIDTH (')	DEPTH (')	AREA (SF)
MIN.	50	100.0	5,000
179	66.2	140.0	9,268
180	66.2	140.0	9,268
181	69.2	140.0	9,688
182	69.2	140.0	9,688
183	52.2	140.0	8,307
184	52.2	140.0	8,307
185	52.3	140.0	7,579
186	55.2	140.0	7,728
187	55.3	140.0	7,721
188	55.2	140.0	7,725
189	55.2	140.0	7,728
190	59.9	140.1	7,924
191	92.8	140.0	10,536
192	92.8	140.0	10,536
193	98.2	140.0	11,144
194	84.2	140.3	10,931
195	68.0	140.0	9,520
196	91.0	140.0	12,654
197	52.2	140.0	7,308
198	55.2	140.0	7,728
199	55.2	140.0	7,751
200	52.2	147.1	7,700
201	52.2	158.5	8,193
202	52.3	146.5	9,701
203	51.0	145.0	12,089
204	51.0	145.0	12,089
205	51.0	145.0	12,089
206	51.0	145.0	12,089
207	53.2	147.4	9,260
208	52.2	162.3	8,400
209	52.2	150.0	7,848
210	52.2	140.6	7,363
211	52.2	140.0	7,308
212	52.2	140.0	7,308
213	86.3	140.0	11,990
214	52.2	140.0	7,308
215	52.2	140.0	7,308
216	52.2	140.0	7,308
217	52.2	140.0	7,308
218	55.2	140.0	7,728
219	55.2	140.0	7,728
220	52.2	142.4	7,469
221	61.7	161.5	9,135
222	64.7	171.3	8,882
223	54.3	140.8	7,426
224	64.9	158.6	8,520
225	80.6	158.9	11,616
226	52.2	140.0	7,308
227	52.2	140.0	7,308
228	52.2	140.0	7,308
229	52.2	140.0	7,308
230	55.2	140.0	7,728
231	55.2	140.0	7,728
232	66.2	140.0	9,268
233	66.2	140.0	9,268
234	66.2	140.0	9,268
235	66.2	140.0	9,268
236	66.2	140.0	9,268
237	66.2	140.0	9,268
238	66.2	140.0	9,268
239	66.2	140.0	9,268
240	69.3	140.1	9,723
241	71.1	149.0	10,351
242	73.0	174.0	11,536
243	83.6	214.2	14,080
244	82.3	185.8	12,286
245	68.9	147.5	9,823
246	66.2	140.0	9,272
247	75.2	140.0	10,528
248	75.2	140.0	10,528
249	77.2	140.0	10,108
250	72.2	140.0	10,108
251	72.2	140.0	10,108
252	75.2	140.0	10,528
253	75.2	140.0	10,528
254	72.2	140.0	10,108
255	72.9	144.2	12,040
256	76.0	202.7	16,379

Estero Fire Rescue

Hydrant Flow Test By Hydrant

Hydrant Number = "15-050" and Date Between
{10/25/2017} And {10/25/2017}


15-050	Corkscrew RD & Cypress Shadows BLVD /1st on left					MUELLER	BSR		
Date	Static	Residual	Pitot	Pitot 2	GPM	20 PSI	10 PSI	0 PSI	
10/25/2017	70	60	37.00	0.00	1021	2435	2687	2920	
668	Green, Phillip Wayne								
Subtotal Flow Tests:		1	Min:	1021	2435	2687	2920		
			Max:	1021	2435	2687	2920		
			Avg:	1021	2435	2687	2920		
Total Flow Tests:		1							






10/25/2017 10:19
* Scheduled Flow Test

Page 1

NOTES

- SEE DETAILED SITE PLANS FOR DRAINAGE PIPE SIZES AND INVERTS.
- ALTERNATE PIPE MATERIALS MAY BE SUBMITTED TO ENGINEER FOR CONSIDERATION.
- INSTALL PIPE AND YARD DRAIN IN ACCORDANCE WITH MANUFACTURERS RECOMMENDATIONS.
- CONTRACTOR MAY UTILIZE LARGER PIPE SIZES THAN THOSE SHOWN ON PLANS AT NO ADDITIONAL COMPENSATION.

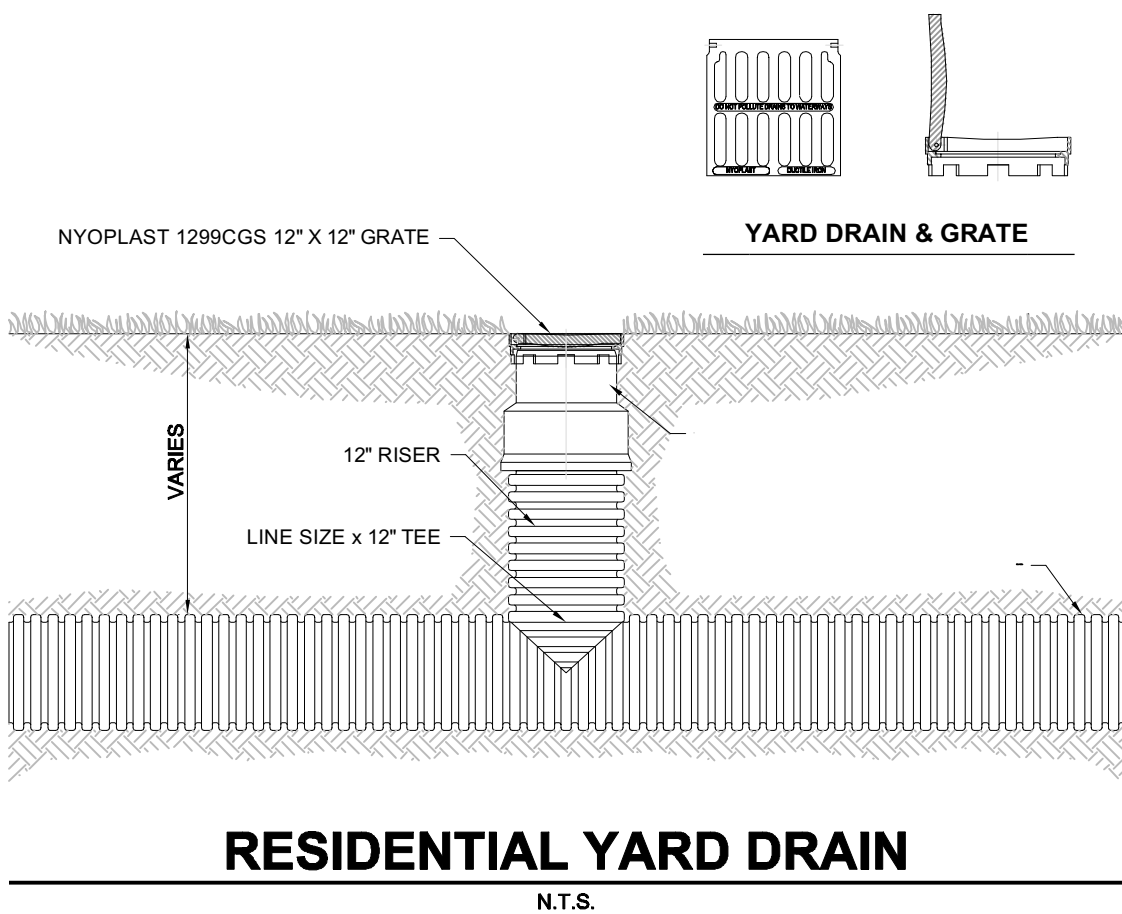

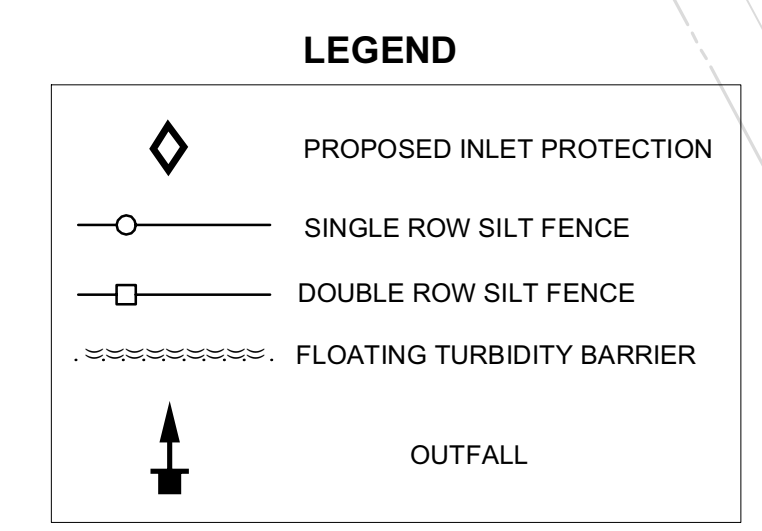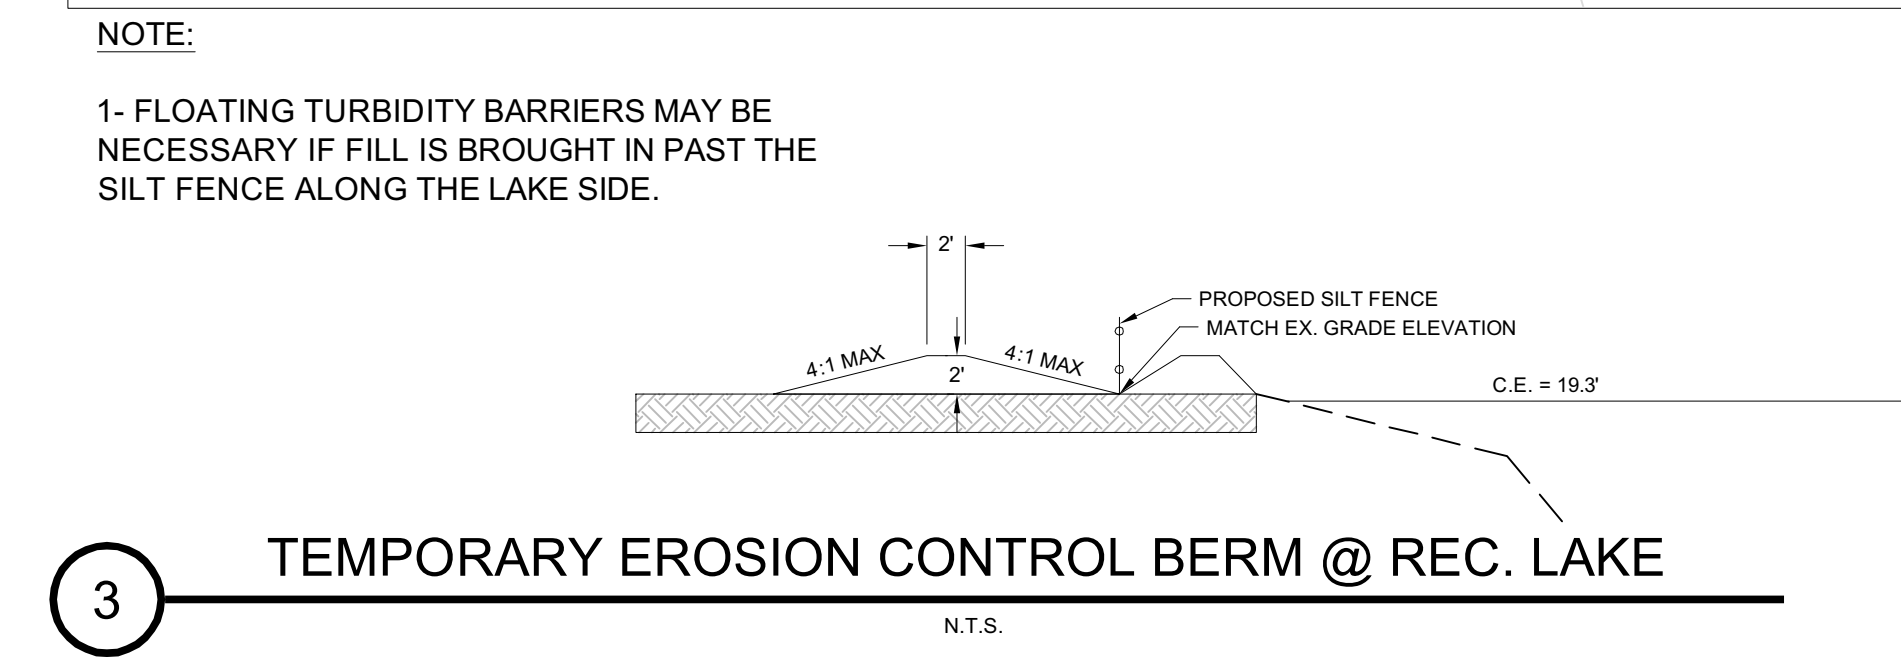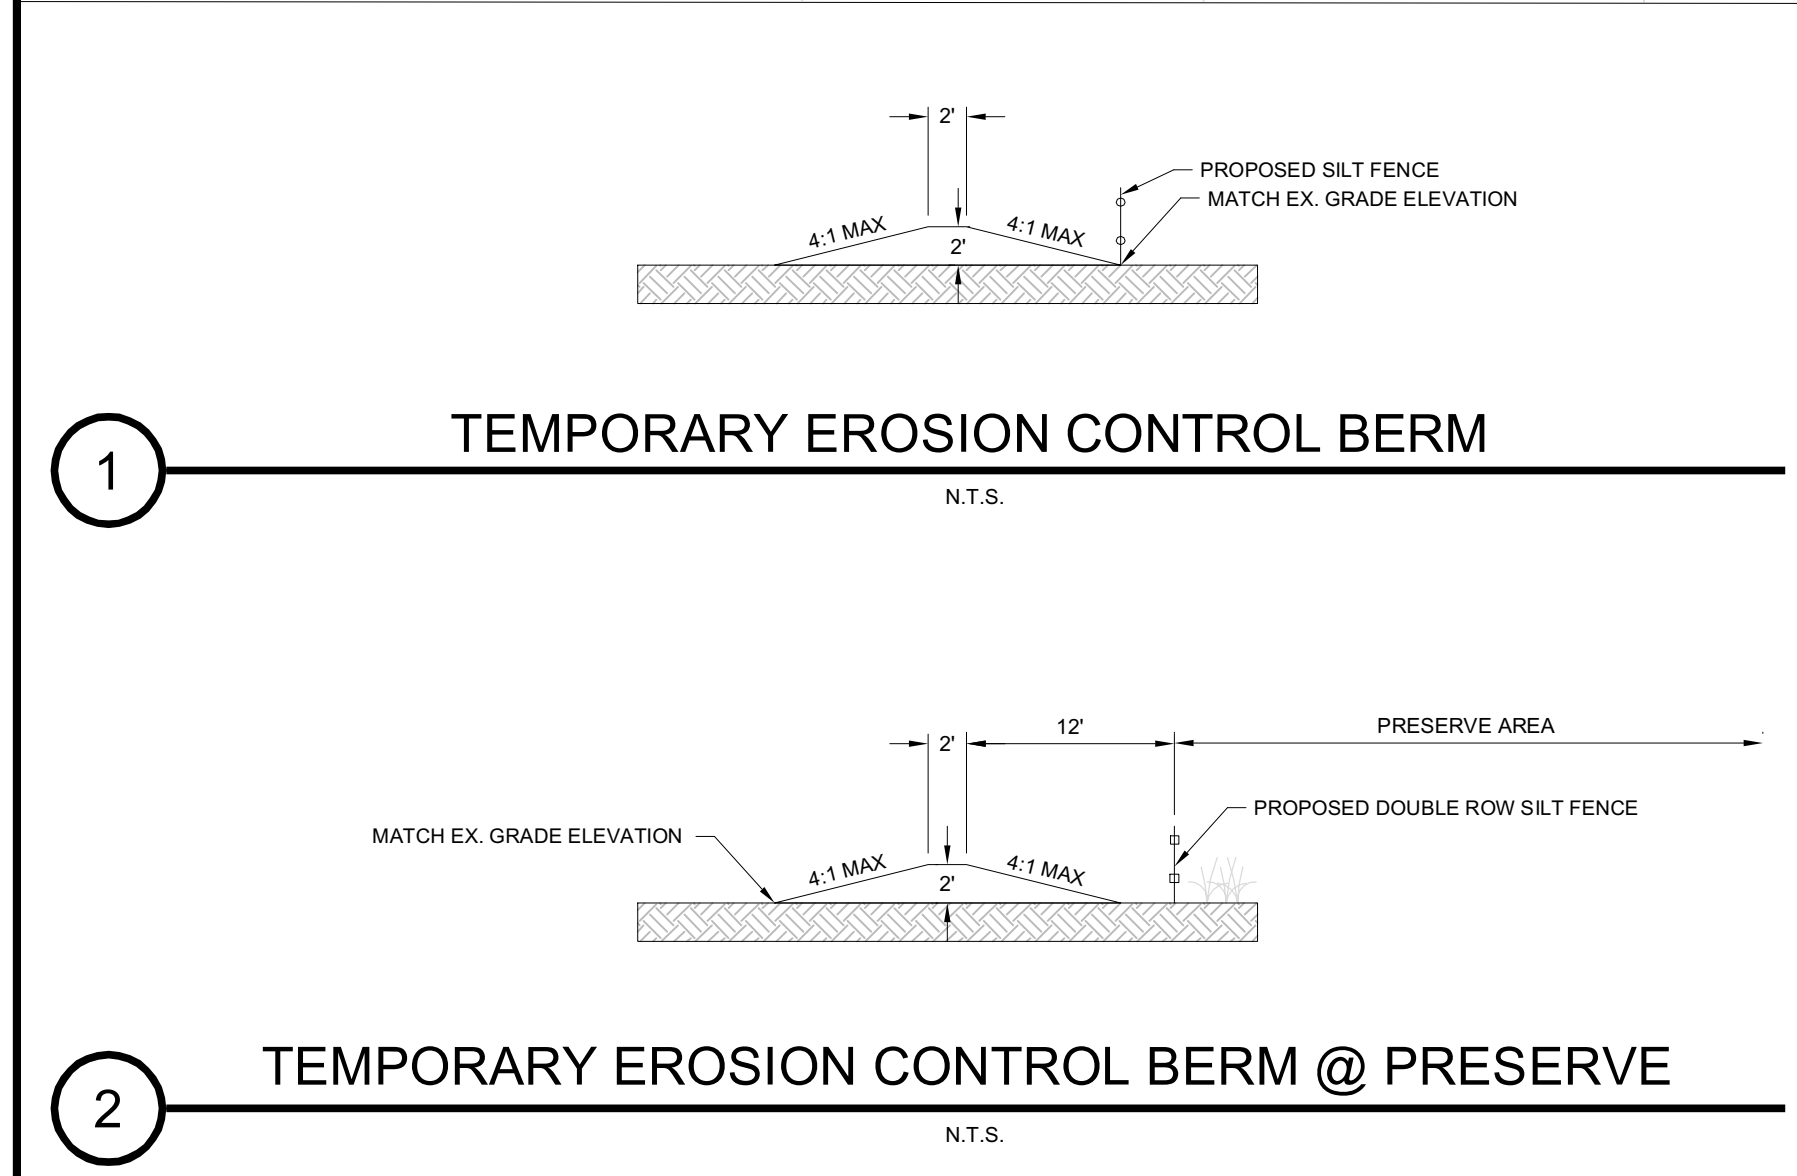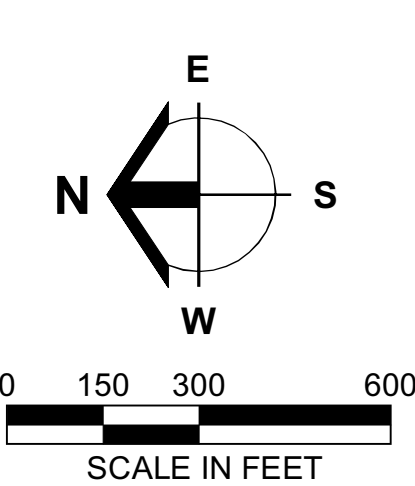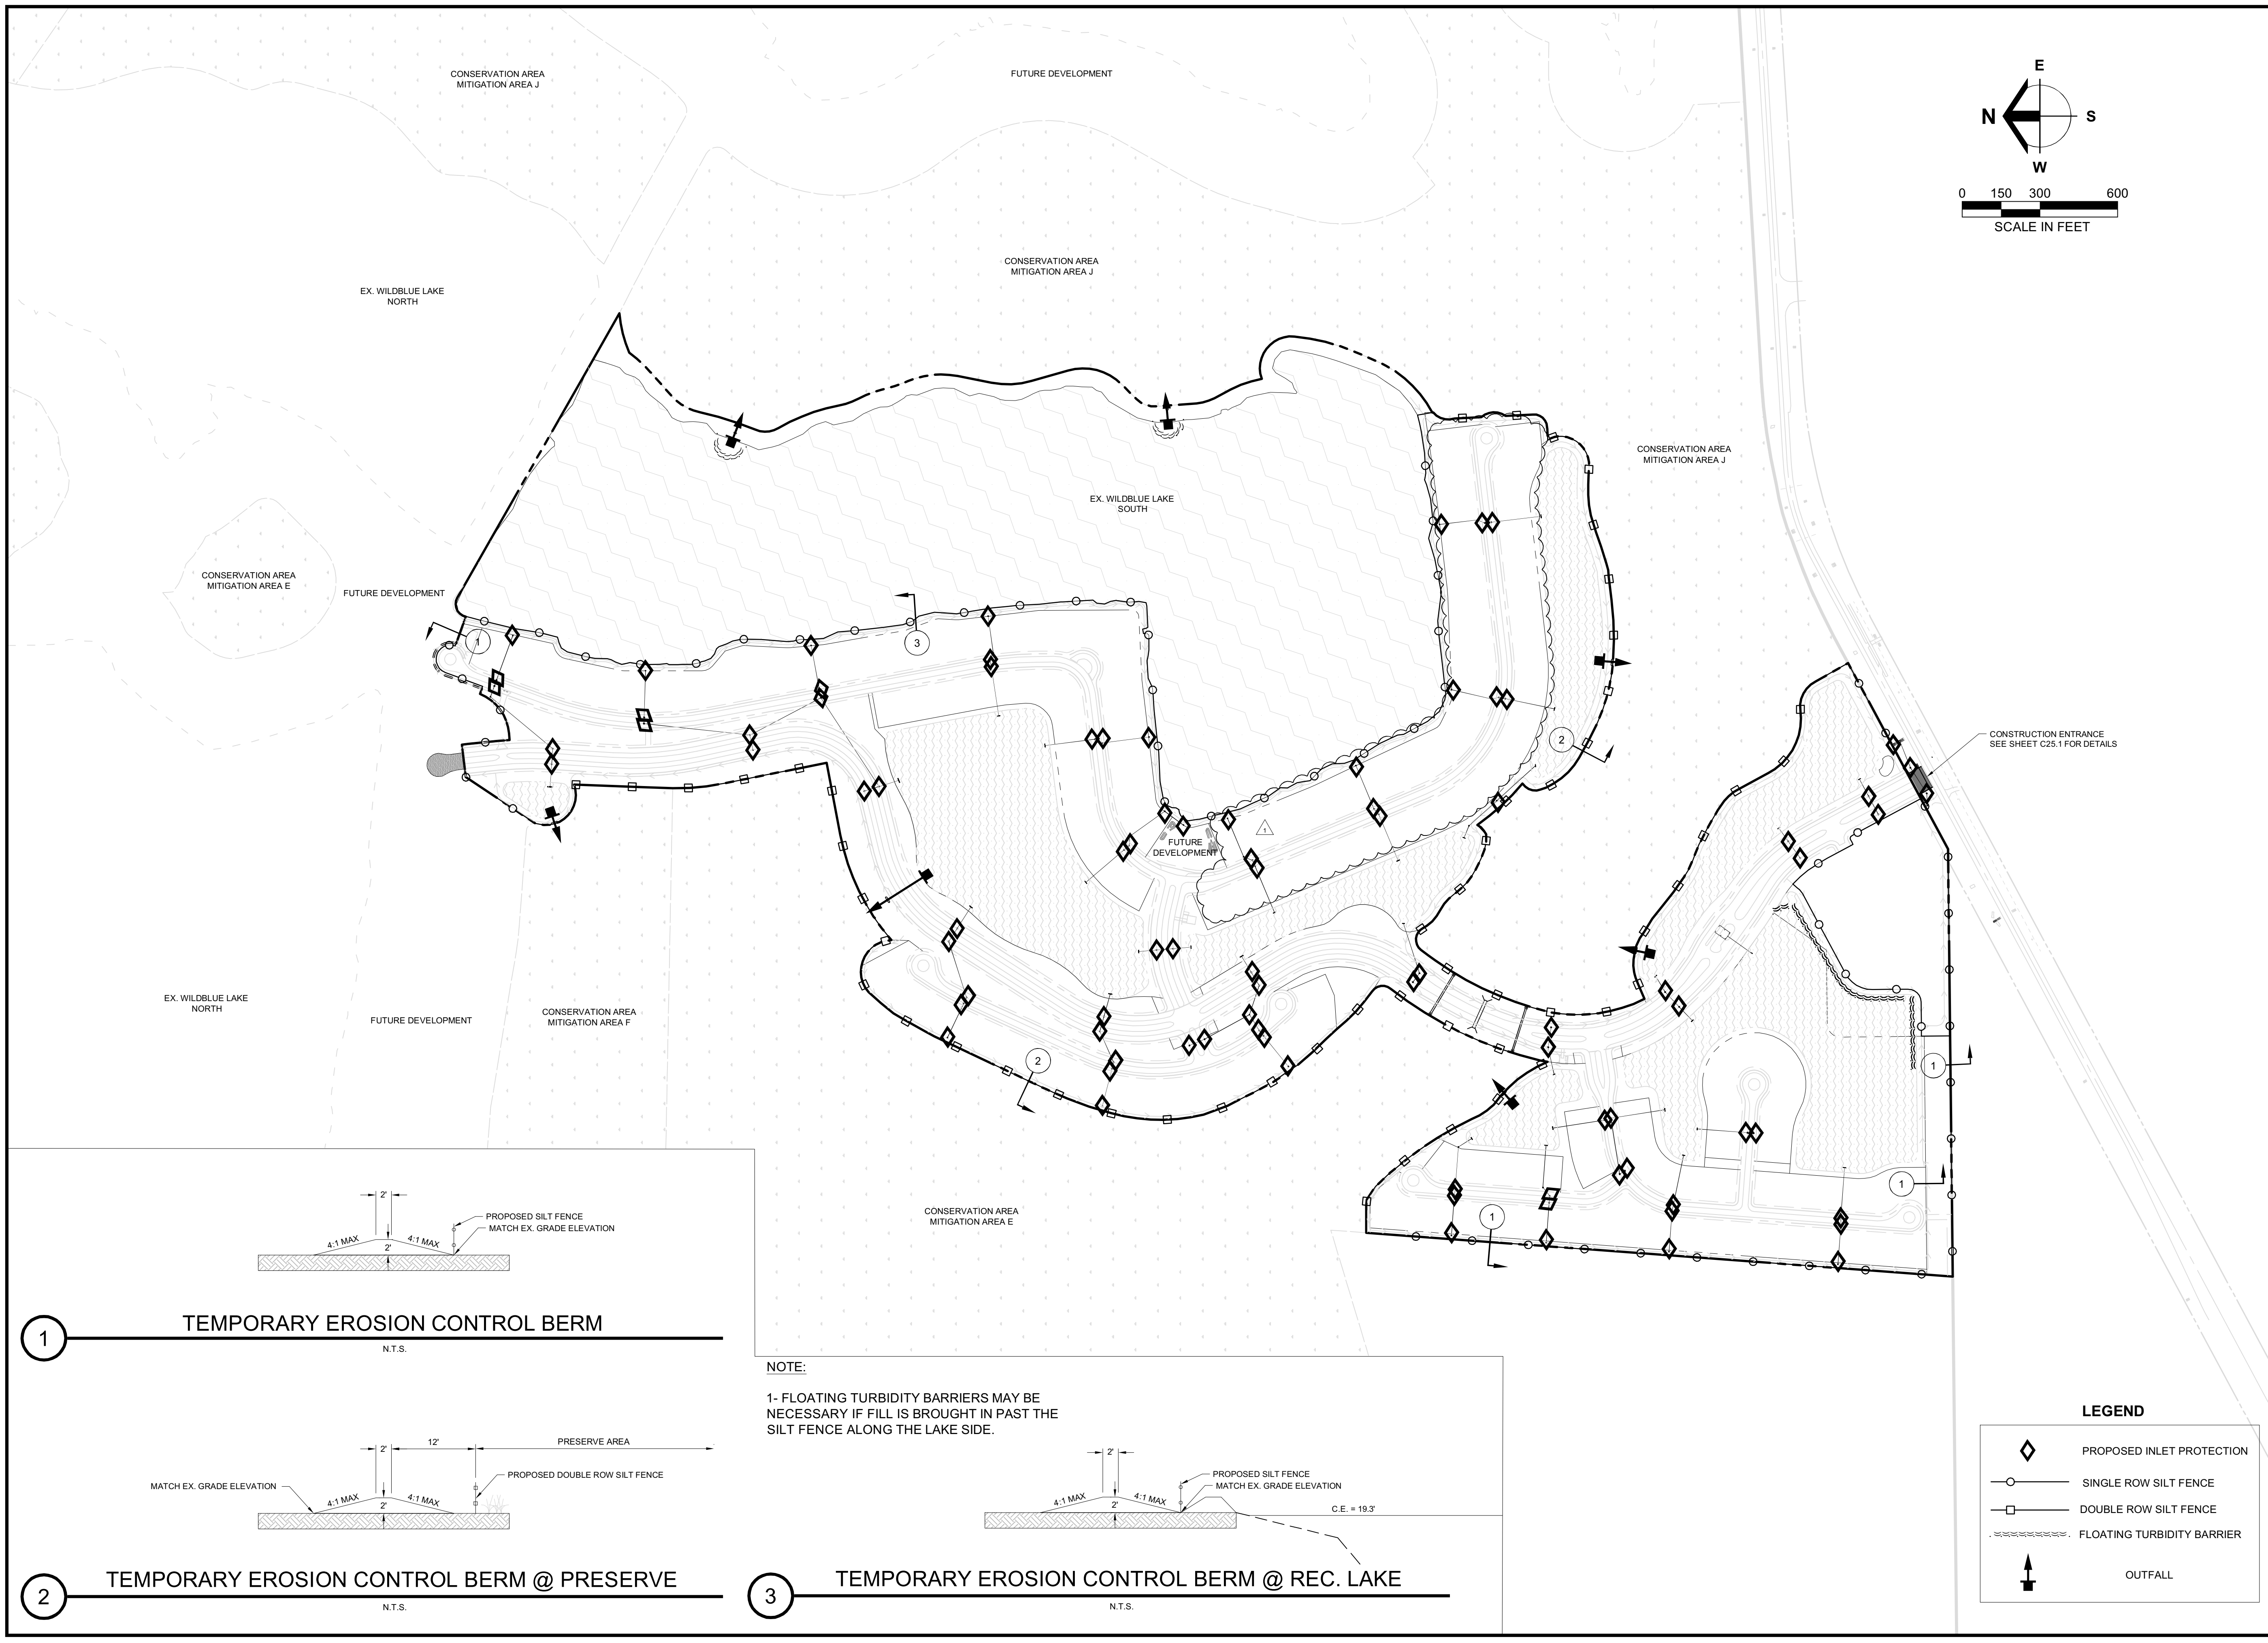

Barraco
and Associates, Inc.
CIVIL ENGINEERING - LAND SURVEYING
LAND PLANNING
www.barraco.net
2271 MCGREGOR BLVD., SUITE 100
POST OFFICE DRAWER 2800
FORT MYERS, FLORIDA 33902-2800
PHONE (239) 461-3170
FAX (239) 461-3169
FLORIDA CERTIFICATES OF AUTHORIZATION
ENGINEERING 7995 - SURVEYING LB-6940

PREPARED FOR

PULTE HOME CORPORATION
24311 WALDEN CENTER DRIVE
SUITE 300
BONITA SPRINGS, FLORIDA 34134
PHONE (239) 498-7711
FAX (239) 498-7707
WWW.PULTEHOMES.COM

PROJECT DESCRIPTION

**WILDBLUE
SOUTHWEST**

LEE COUNTY, FLORIDA

ENGINEER OF RECORD
CARL A. BARRACO, P.E. FOR THE FIRM
FLORIDA P.E. NO. 38536 - CARLB@BARRACO.NET

DRAWING NOT VALID WITHOUT SEAL, SIGNATURE AND DATE.
© COPYRIGHT 2019, BARRACO AND ASSOCIATES, INC.
REPRODUCTION, CHANGES OR ASSIGNMENTS ARE PROHIBITED

FILE NAME J:\23526\DWG\DO SPINE ROAD.DWG

LOCATION J:\23526\DWG\DO SPINE ROAD.DWG

PLOT DATE WED, 6-5-2019 - 2:33 PM

PLOT BY SCOTT WHEELER JR

CROSS REFERENCED DRAWINGS

PLAN REVISIONS

DATE	DESCRIPTION	BY
06-03-19	D.O. AMENDMENT #3 CHANGES	

PLAN STATUS

D.O. AMENDMENT #3
06-05-2019



**STORMWATER
POLLUTION
PREVENTION PLAN**

PROJECT / FILE NO. **23526**

SHEET NUMBER **C21.0**



MSA MESA LED

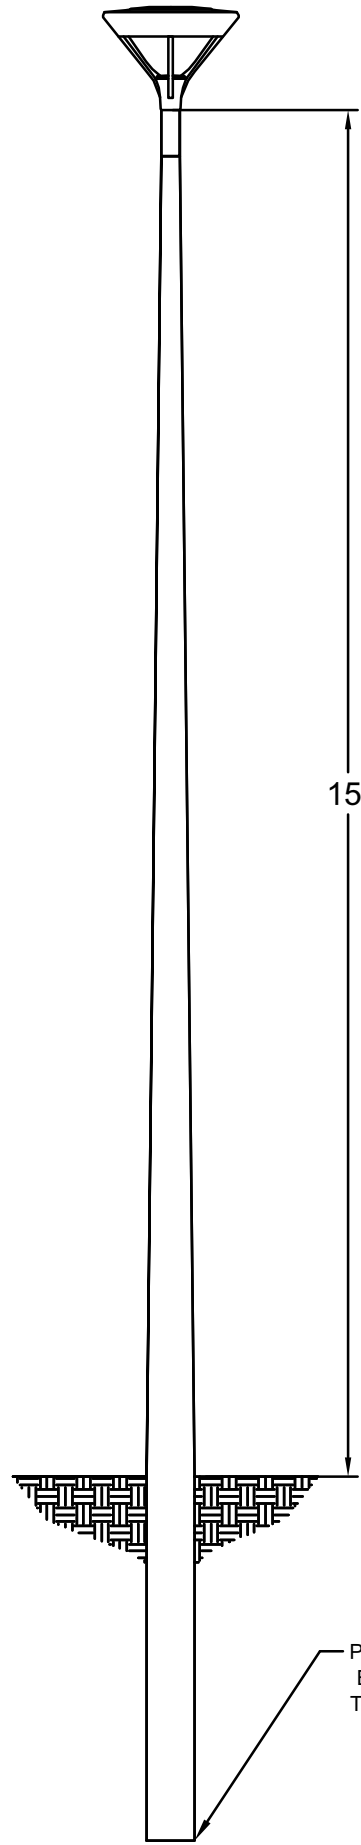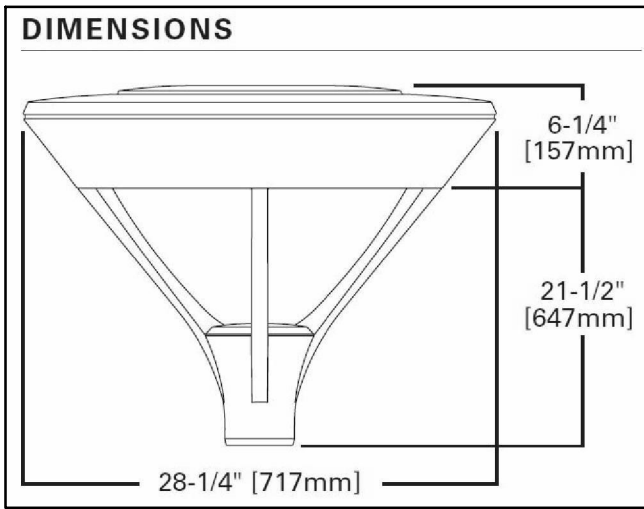


POLES SHALL BE DIRECT
BURIAL OR FOUNDATIONS
TO BE DESIGNED BY OTHERS

NOTE:

1. LIGHT POLE FOUNDATIONS TO BE A MINIMUM OF 5' FROM ANY EXISTING OR PROPOSED LCU OWNED AND MAINTAINED PIPELINE OR FACILITY
2. NO DIRECT ILLUMINATION IN THE INDIGENOUS PRESERVE OR RESTORATION AREA IS PROPOSED
3. THERE ARE (2) MSA-E03-LED-E1-T3, ON WILDBLUE BLVD. BEFORE THE INTERSECTION WITH AQUA VIEW LANE.

LUMINAIRE SCHEDULE							
SYMBOL	QTY	LABEL	ARRANGEMENT	TOTAL LAMP LUMENS	GLARE RATING (BUG)	LLF	DESCRIPTION
(RESIDENTIAL)	112	MSA-E03-LED-E1-T3	SINGLE	7,456	B2-U0-G2	1.000	MSA-E03-LED-E1-T3
(SPINE ROAD)	120	MSA-E06-LED-E1-T3	SINGLE	14,911	B3-U0-G3	1.000	MSA-E06-LED-E1-T3

CALCULATION SUMMARY							
Label	CalcType	Units	Avg	Max	Min	Avg/Min	Max/Min
Preserve/ Corkscrew Right of Way	Illuminance	Fc	0.00	0.0	0.0	N.A.	N.A.
Residential	Illuminance	Fc	1.41	5.4	0.0	N.A.	N.A.
SpineRoad	Illuminance	Fc	2.40	5.7	0.2	N.A.	N.A.

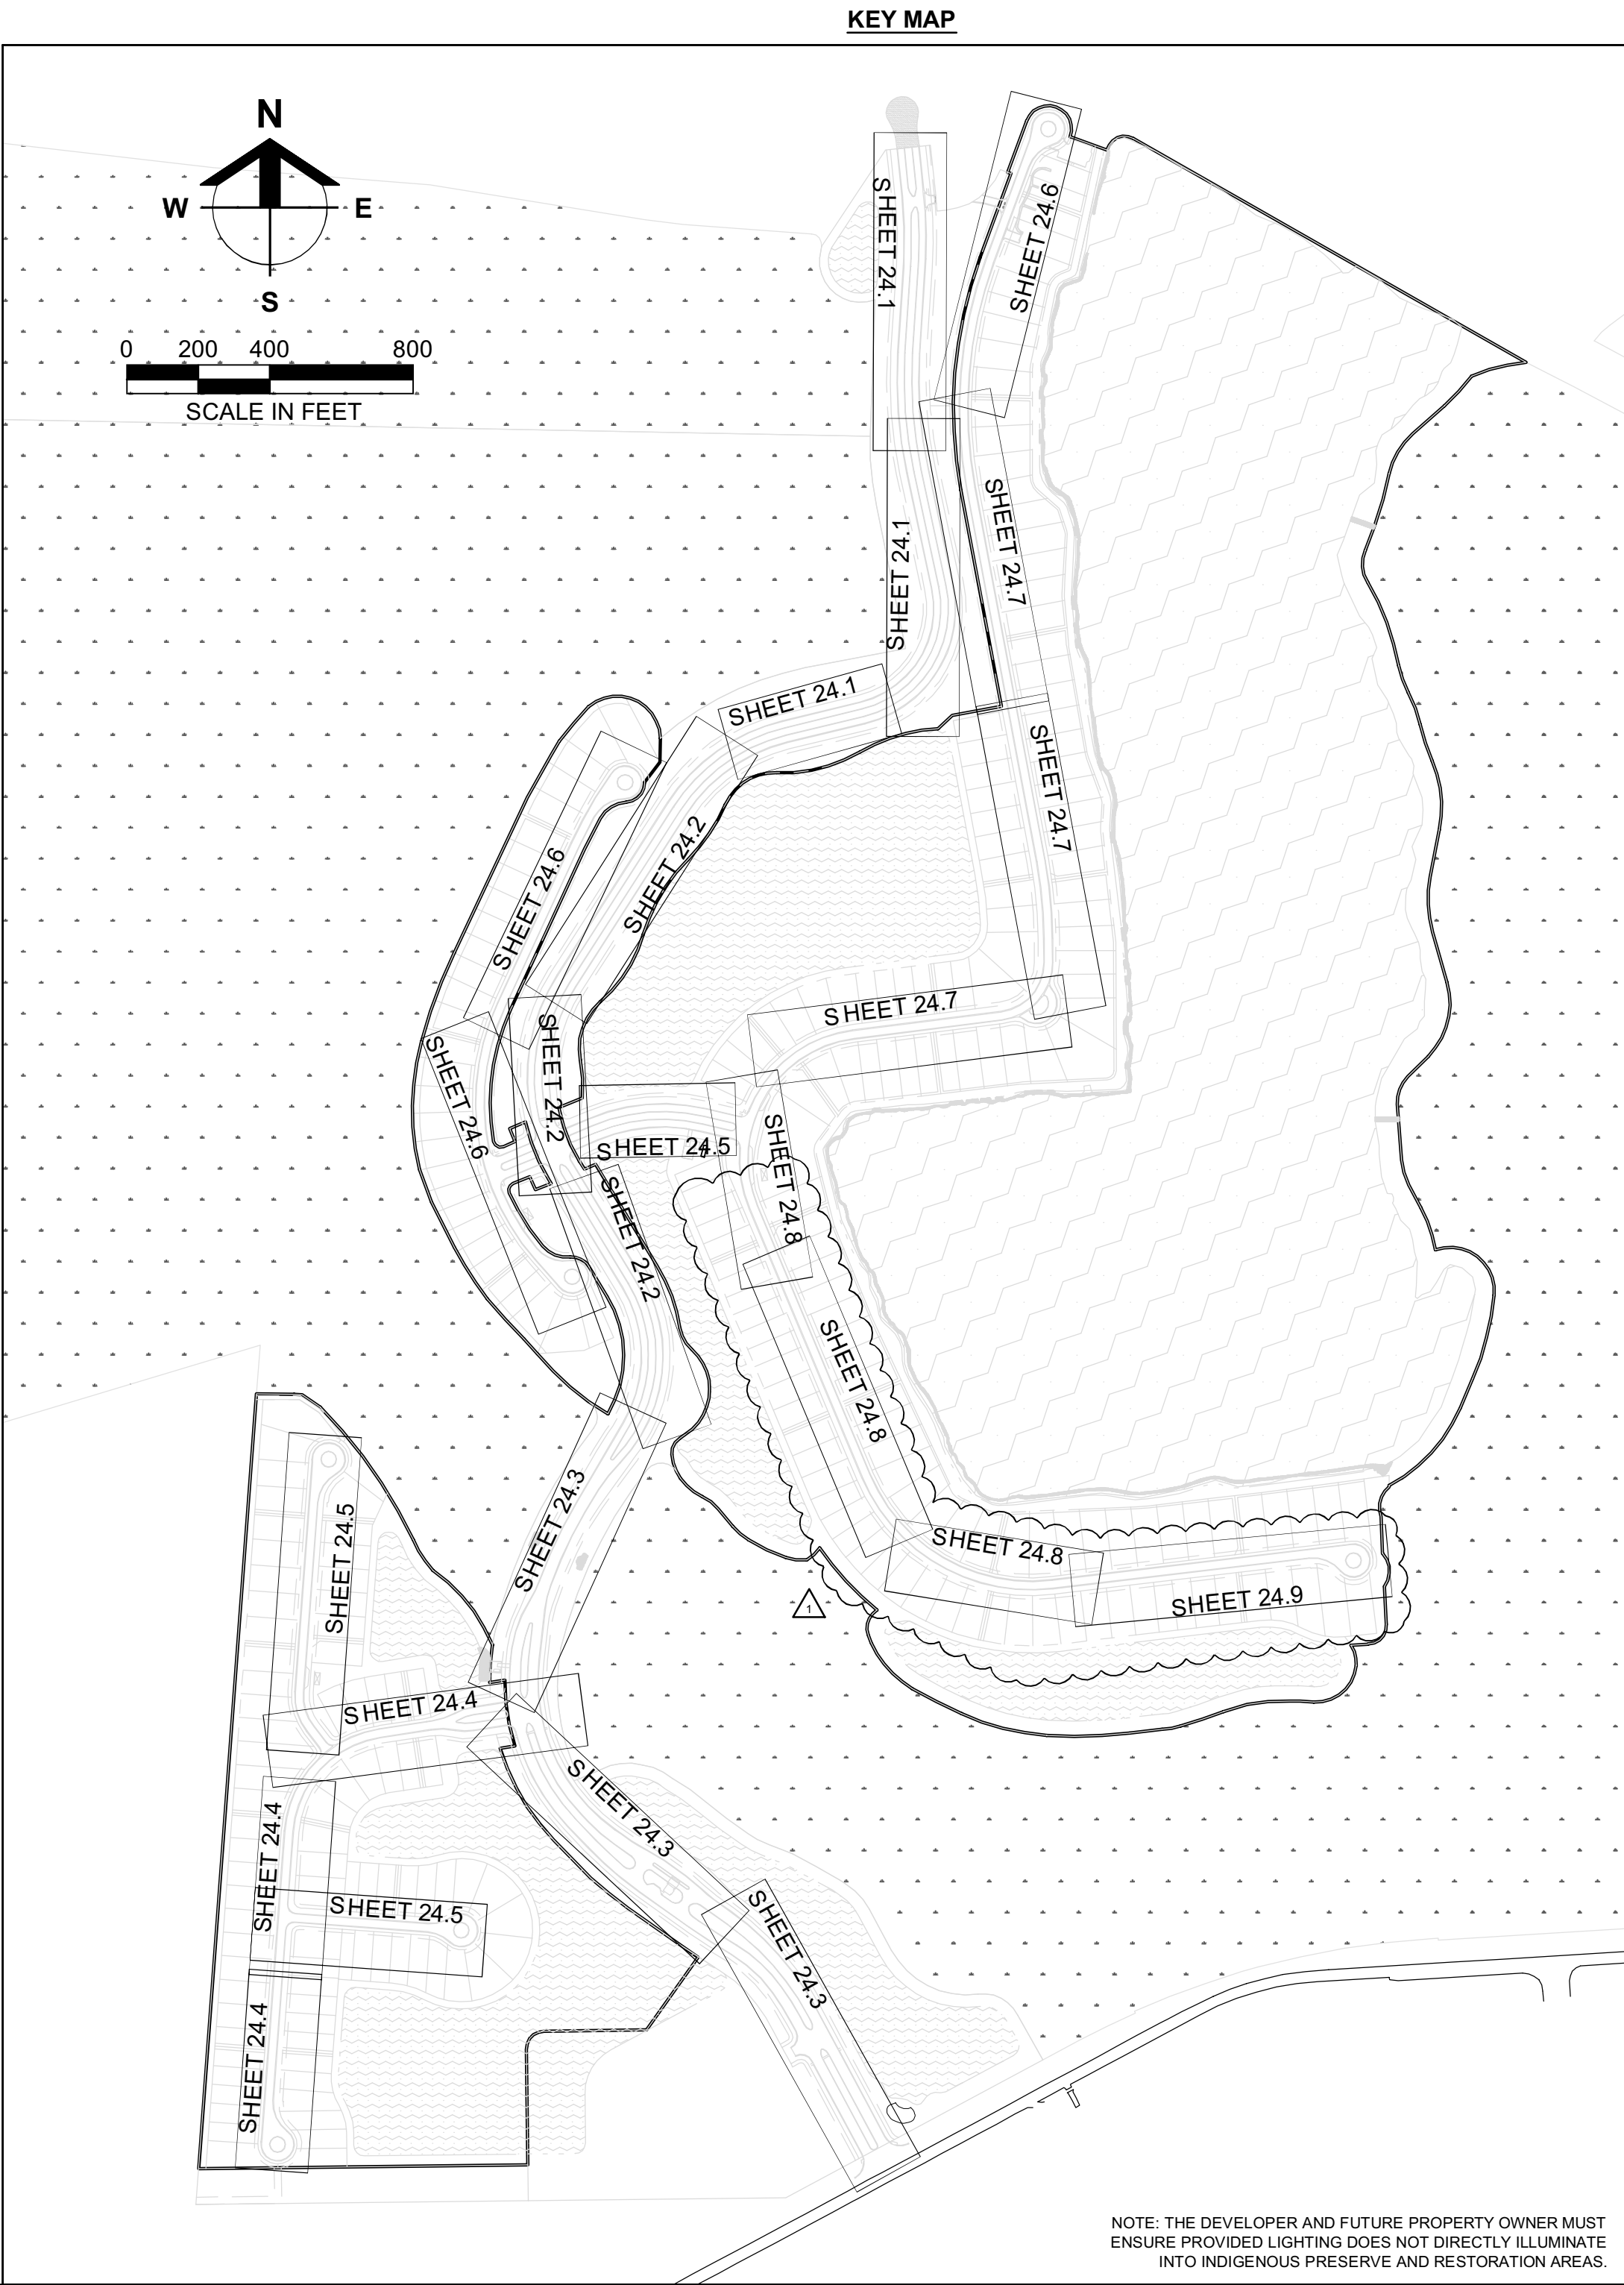

Barraco

and Associates, Inc.

CIVIL ENGINEERING - LAND SURVEYING
LAND PLANNING

www.barraco.net

2271 MCGREGOR BLVD., SUITE 100
POST OFFICE DRAWER 2800
FORT MYERS, FLORIDA 33902-2800
PHONE (239) 461-3170
FAX (239) 461-3169

FLORIDA CERTIFICATES OF AUTHORIZATION
ENGINEERING 7995 - SURVEYING LB-6940

PREPARED FOR

PULTE
HOMES

PULTE HOME CORPORATION
24311 WALDEN CENTER DRIVE
SUITE 300
BONITA SPRINGS, FLORIDA 34134

PHONE (239) 498-7711
FAX (239) 498-7707

WWW.PULTEHOMES.COM

PROJECT DESCRIPTION

WILDBLUE
SOUTHWEST

LEE COUNTY, FLORIDA

ENGINEER OF RECORD
CARL A. BARRACO, P.E., FOR THE FIRM
FLORIDA P.E. NO. 38536 - CARLB@BARRACO.NET

DRAWING NOT VALID WITHOUT SEAL, SIGNATURE AND DATE.
© COPYRIGHT 2019, BARRACO AND ASSOCIATES, INC.
REPRODUCTION, CHANGES OR ASSIGNMENTS ARE PROHIBITED

FILE NAME J:\23526\DWG\DO SPINE ROAD\DWG
LOCATION J:\23526\DWG\DO SPINE ROAD\DWG
PLOT DATE WED, 6-5-2019 - 2:34 PM
PLOT BY SCOTT WHEELER JR



 
CROSS REFERENCED DRAWINGS
BASEPLAN = 23526A00.DWG

PLAN REVISIONS
06-03-19 D.O. AMENDMENT #3 CHANGES

PLAN STATUS
D.O. AMENDMENT #3
06-05-2019

LIGHTING PLAN
KEY MAP
& DETAILS

PROJECT / FILE NO. 23526
SHEET NUMBER C24.0

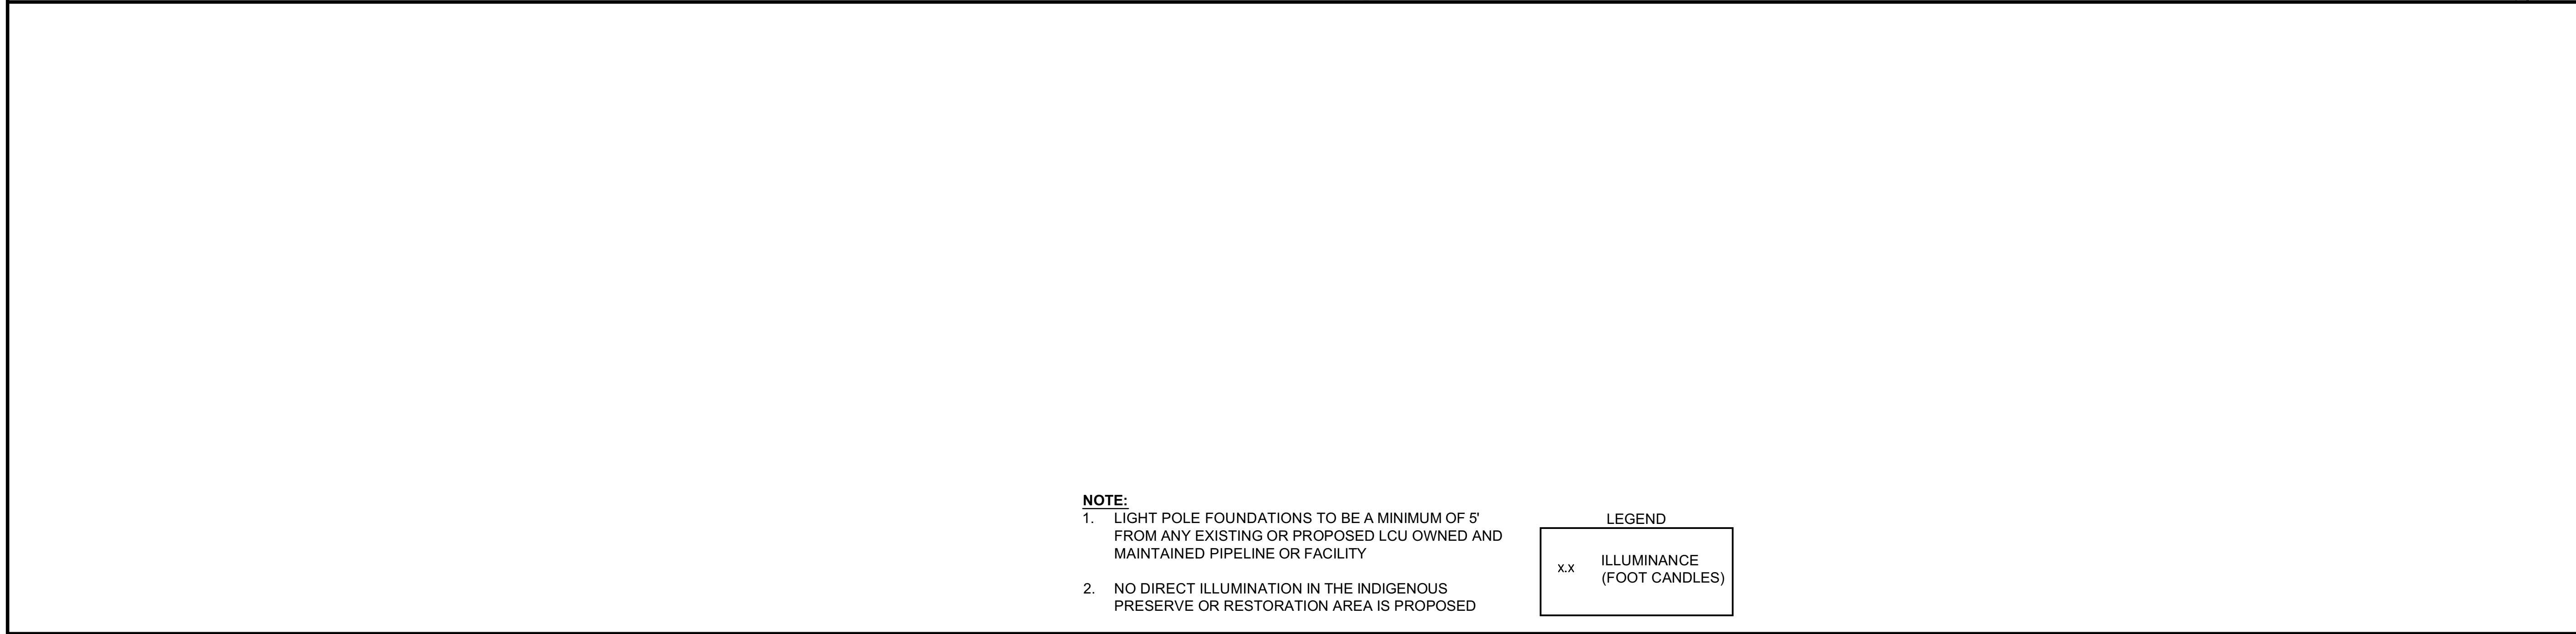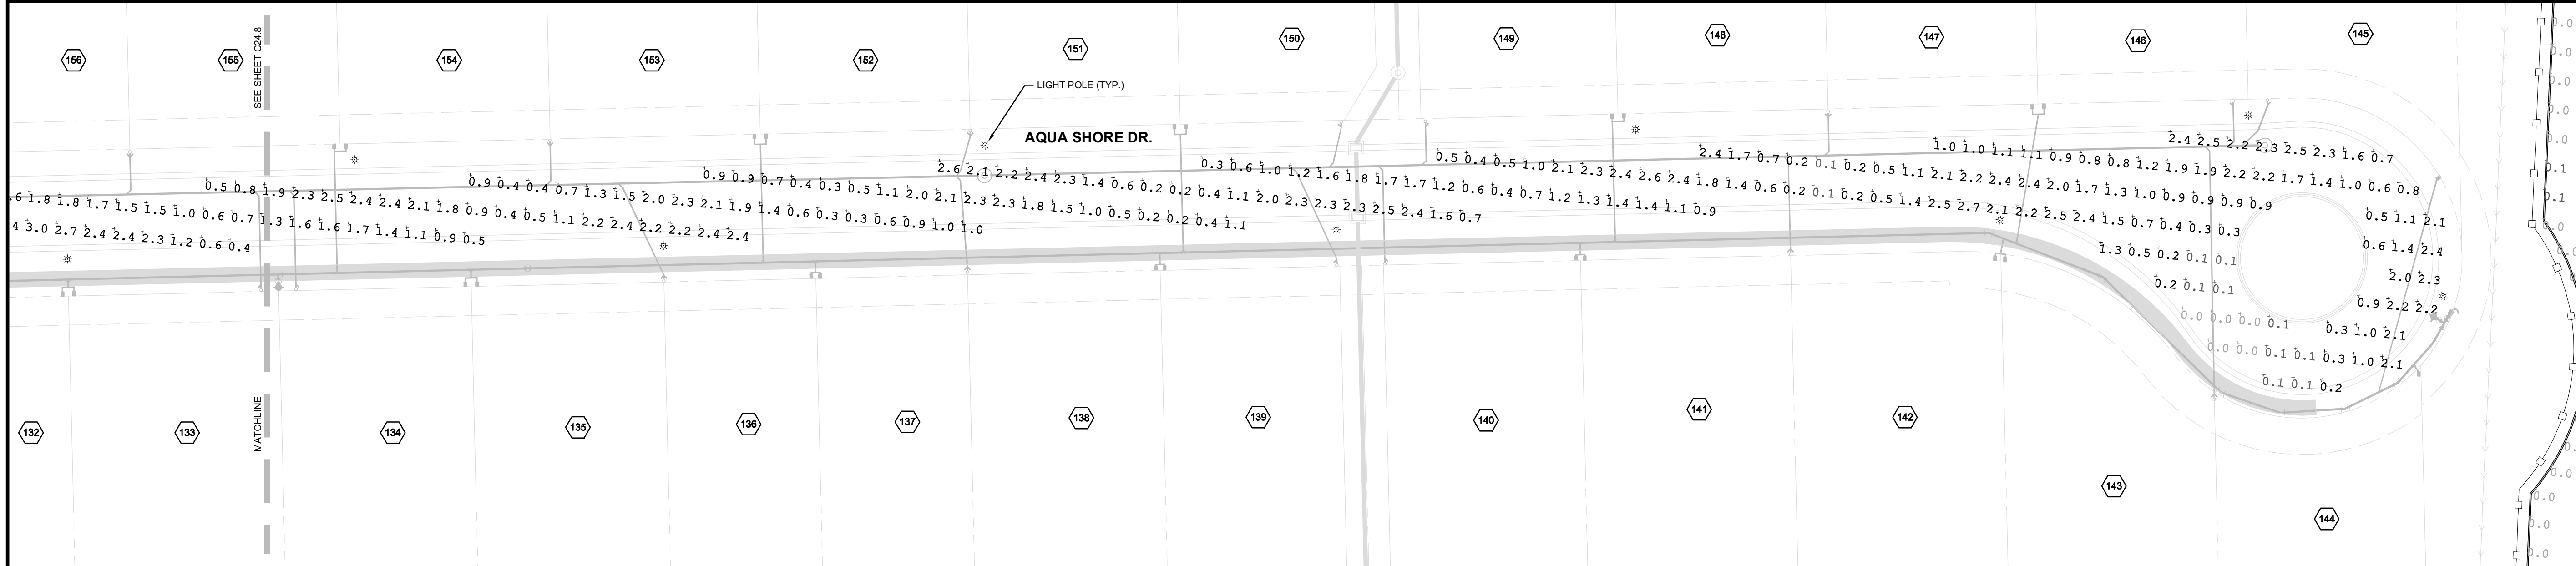

- NOTE:**
1. LIGHT POLE FOUNDATIONS TO BE A MINIMUM OF 5' FROM ANY EXISTING OR PROPOSED LCU OWNED AND MAINTAINED PIPELINE OR FACILITY
 2. NO DIRECT ILLUMINATION IN THE INDIGENOUS PRESERVE OR RESTORATION AREA IS PROPOSED

LEGEND	
x.x	ILLUMINANCE (FOOT CANDLES)

Barraco

and Associates, Inc.

CIVIL ENGINEERING - LAND SURVEYING
LAND PLANNING

www.barraco.net

2271 MCGREGOR BLVD., SUITE 100
POST OFFICE DRAWER 2800
FORT MYERS, FLORIDA 33902-2800
PHONE (239) 461-3170
FAX (239) 461-3169

FLORIDA CERTIFICATES OF AUTHORIZATION
ENGINEERING 7995 - SURVEYING LB-6940

PREPARED FOR

Pulte

Homeworks

PULTE HOME CORPORATION
24311 WALDEN CENTER DRIVE
SUITE 300
BONITA SPRINGS, FLORIDA 34134

PHONE (239) 498-7711
FAX (239) 498-7707

WWW.PULTEHOMES.COM

PROJECT DESCRIPTION

WILDBLUE
SOUTHWEST

LEE COUNTY, FLORIDA

ENGINEER OF RECORD
CARL A. BARRACO, P.E., FOR THE FIRM
FLORIDA P.E. NO. 38536 - CARLB@BARRACO.NET

DRAWING NOT VALID WITHOUT SEAL, SIGNATURE AND DATE.
© COPYRIGHT 2019, BARRACO AND ASSOCIATES, INC.
REPRODUCTION, CHANGES OR ASSIGNMENTS ARE PROHIBITED

FILE NAMEJ:\23526\DWG\DO SPINE ROADJ

PLOT DATEWED. 6-5-2019 - 2:34 PM

PLOT BYSCOTT WHEELER JR

CROSS REFERENCED DRAWINGS

BASEPLAN = 23526A00.DWG

PLAN REVISIONS

PLAN STATUS

D.O. AMENDMENT #3
06-05-2019

△ STREET
LIGHTING PLANS

PROJECT / FILE NO.
23526

SHEET NUMBER
C24.9